


NOTE: ELECTRICAL UTILITIES DEPICTED WITHIN THIS PLAN SET ARE FOR INFORMATIONAL PURPOSES ONLY. SEE ELECTRICAL PLANS (TYP.)

Drawn By	JCH
Designed By	BOH
Date	12/20/2010
Scale	1" = 100'
Checked	JT
Approved	BOH


HIGHLAND WIND PROJECT
HIGHLAND WIND LLC
 Project Location
 HIGHLAND PLANTATION
 INDEX SHEET
 ACCESS HIGHLAND PLANTATION

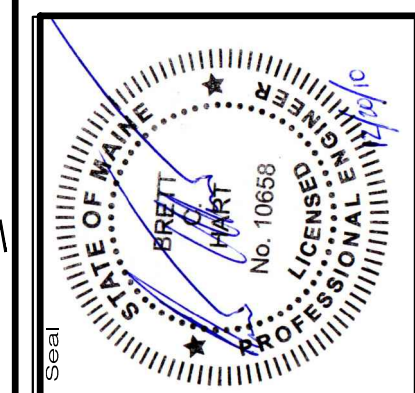



6060E
SEWALL
 JAMES W. SEWALL COMPANY / Since 1887
 SEWALL.COM 800 648 4202

PERMIT
 Sheet No.
C-100

NOT FOR CONSTRUCTION

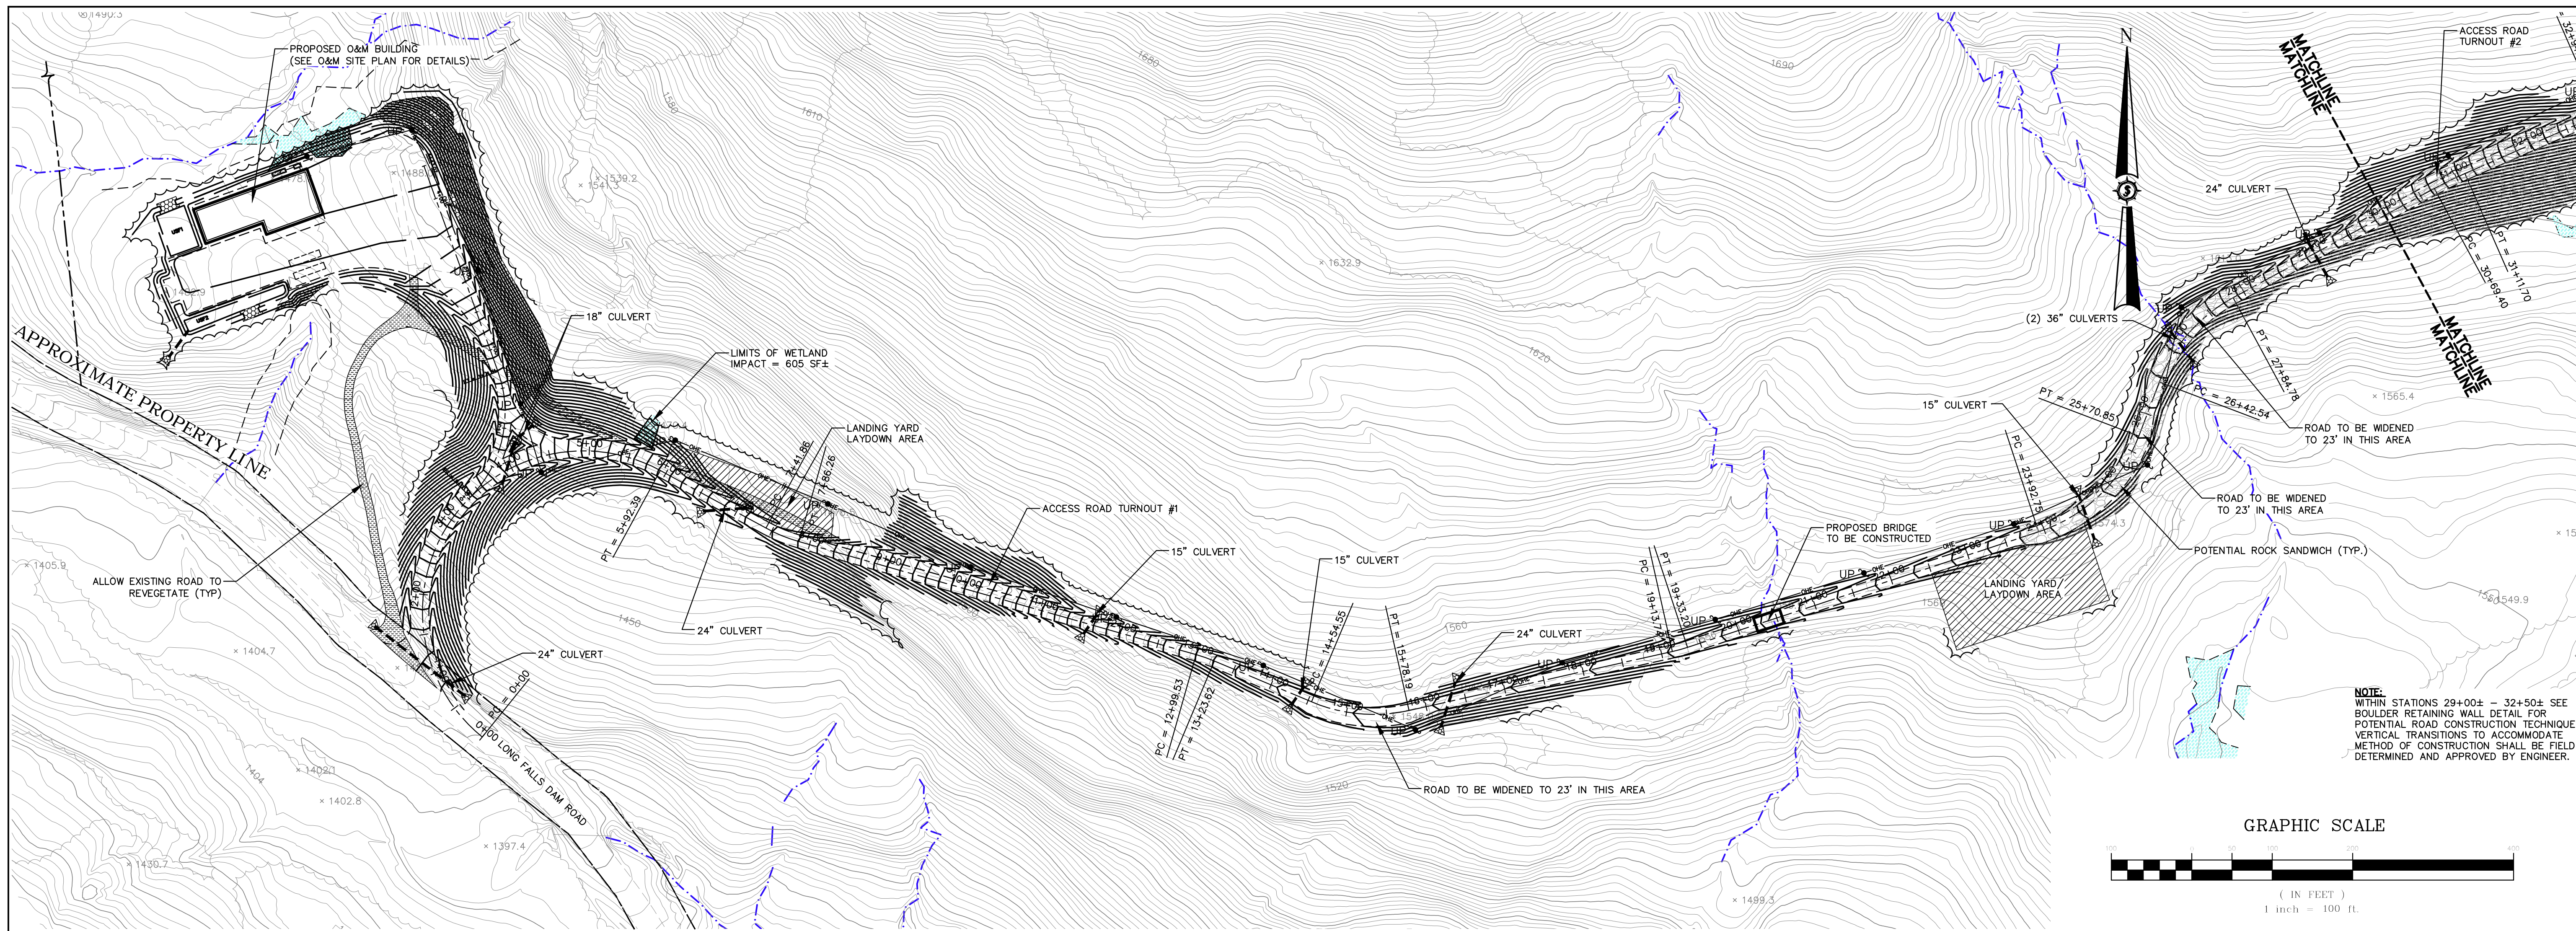

NOTE:
 WITHIN STATIONS 29+00± - 32+50± SEE BOULDER RETAINING WALL DETAIL FOR POTENTIAL ROAD CONSTRUCTION TECHNIQUE. VERTICAL TRANSITIONS TO ACCOMMODATE METHOD OF CONSTRUCTION SHALL BE FIELD DETERMINED AND APPROVED BY ENGINEER.

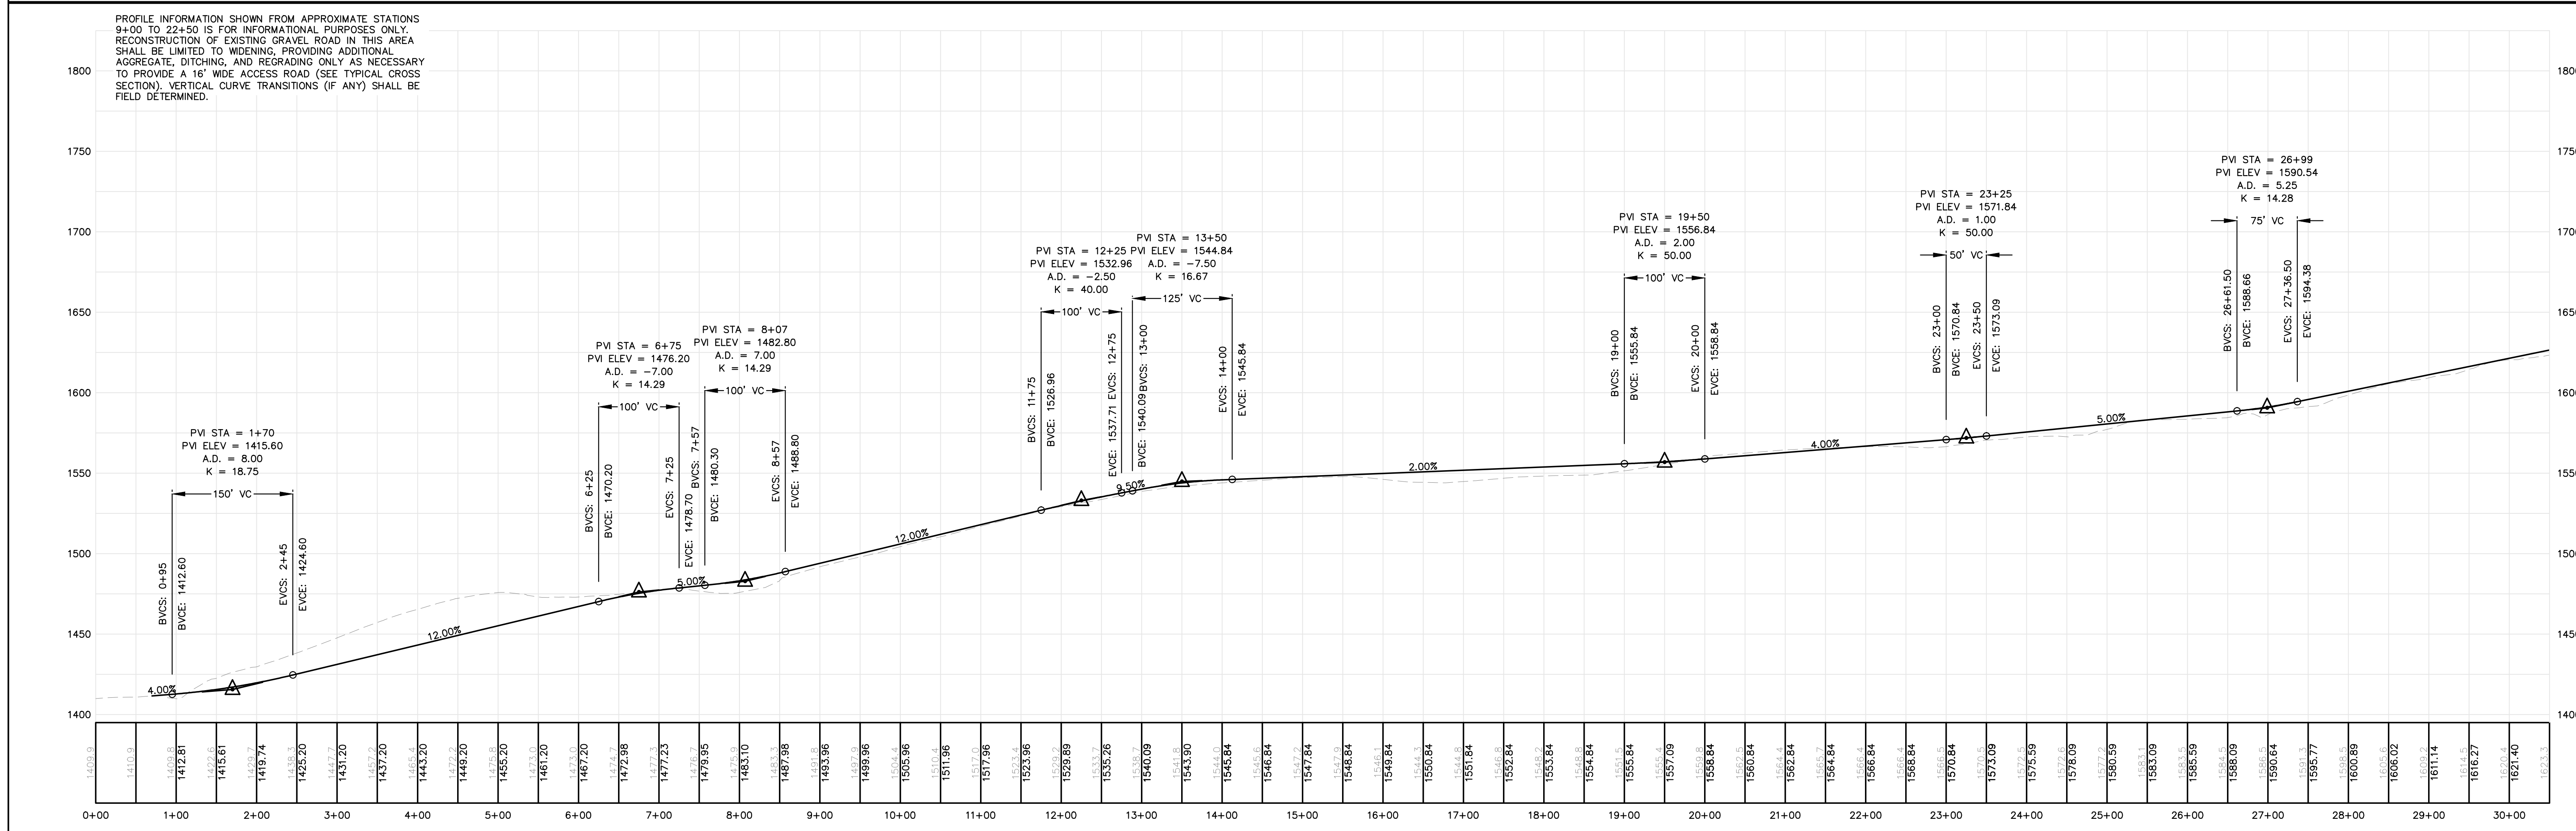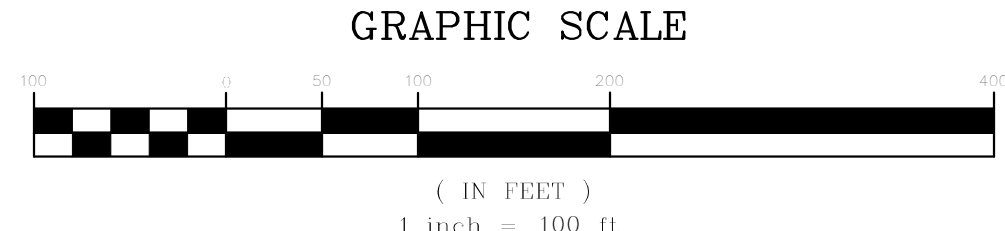


Date	
Drawn By	JCH
Designated By	BOH
Date	12/20/2010
Scale	H: 1"=100' V: 1"=50'
Checked	JT
Approved	BOH

HIGHLAND WIND PROJECT
HIGHLAND WIND LLC

Project Location
 HIGHLAND PLANTATION



Drawing Description
 ACCESS ROAD
 STA. 0+00 TO 30+00

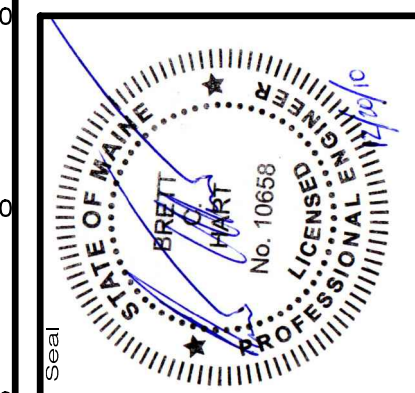


66060E

SEWALL
 an integrated team of
 geospatial, engineering,
 surveying and natural
 resource consultants

JAMES W. SEWALL COMPANY / Since 1881
 800 646 4202
 SEWALL.COM

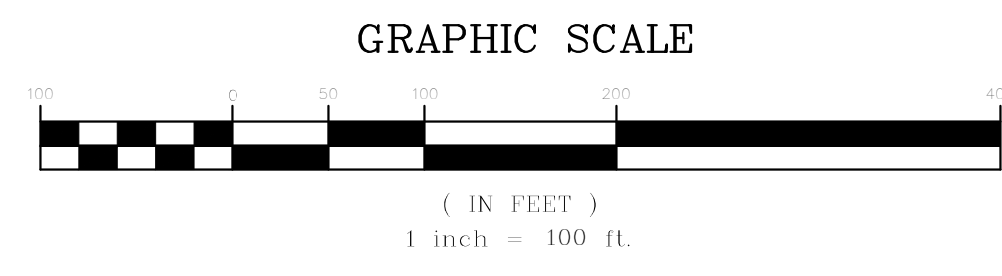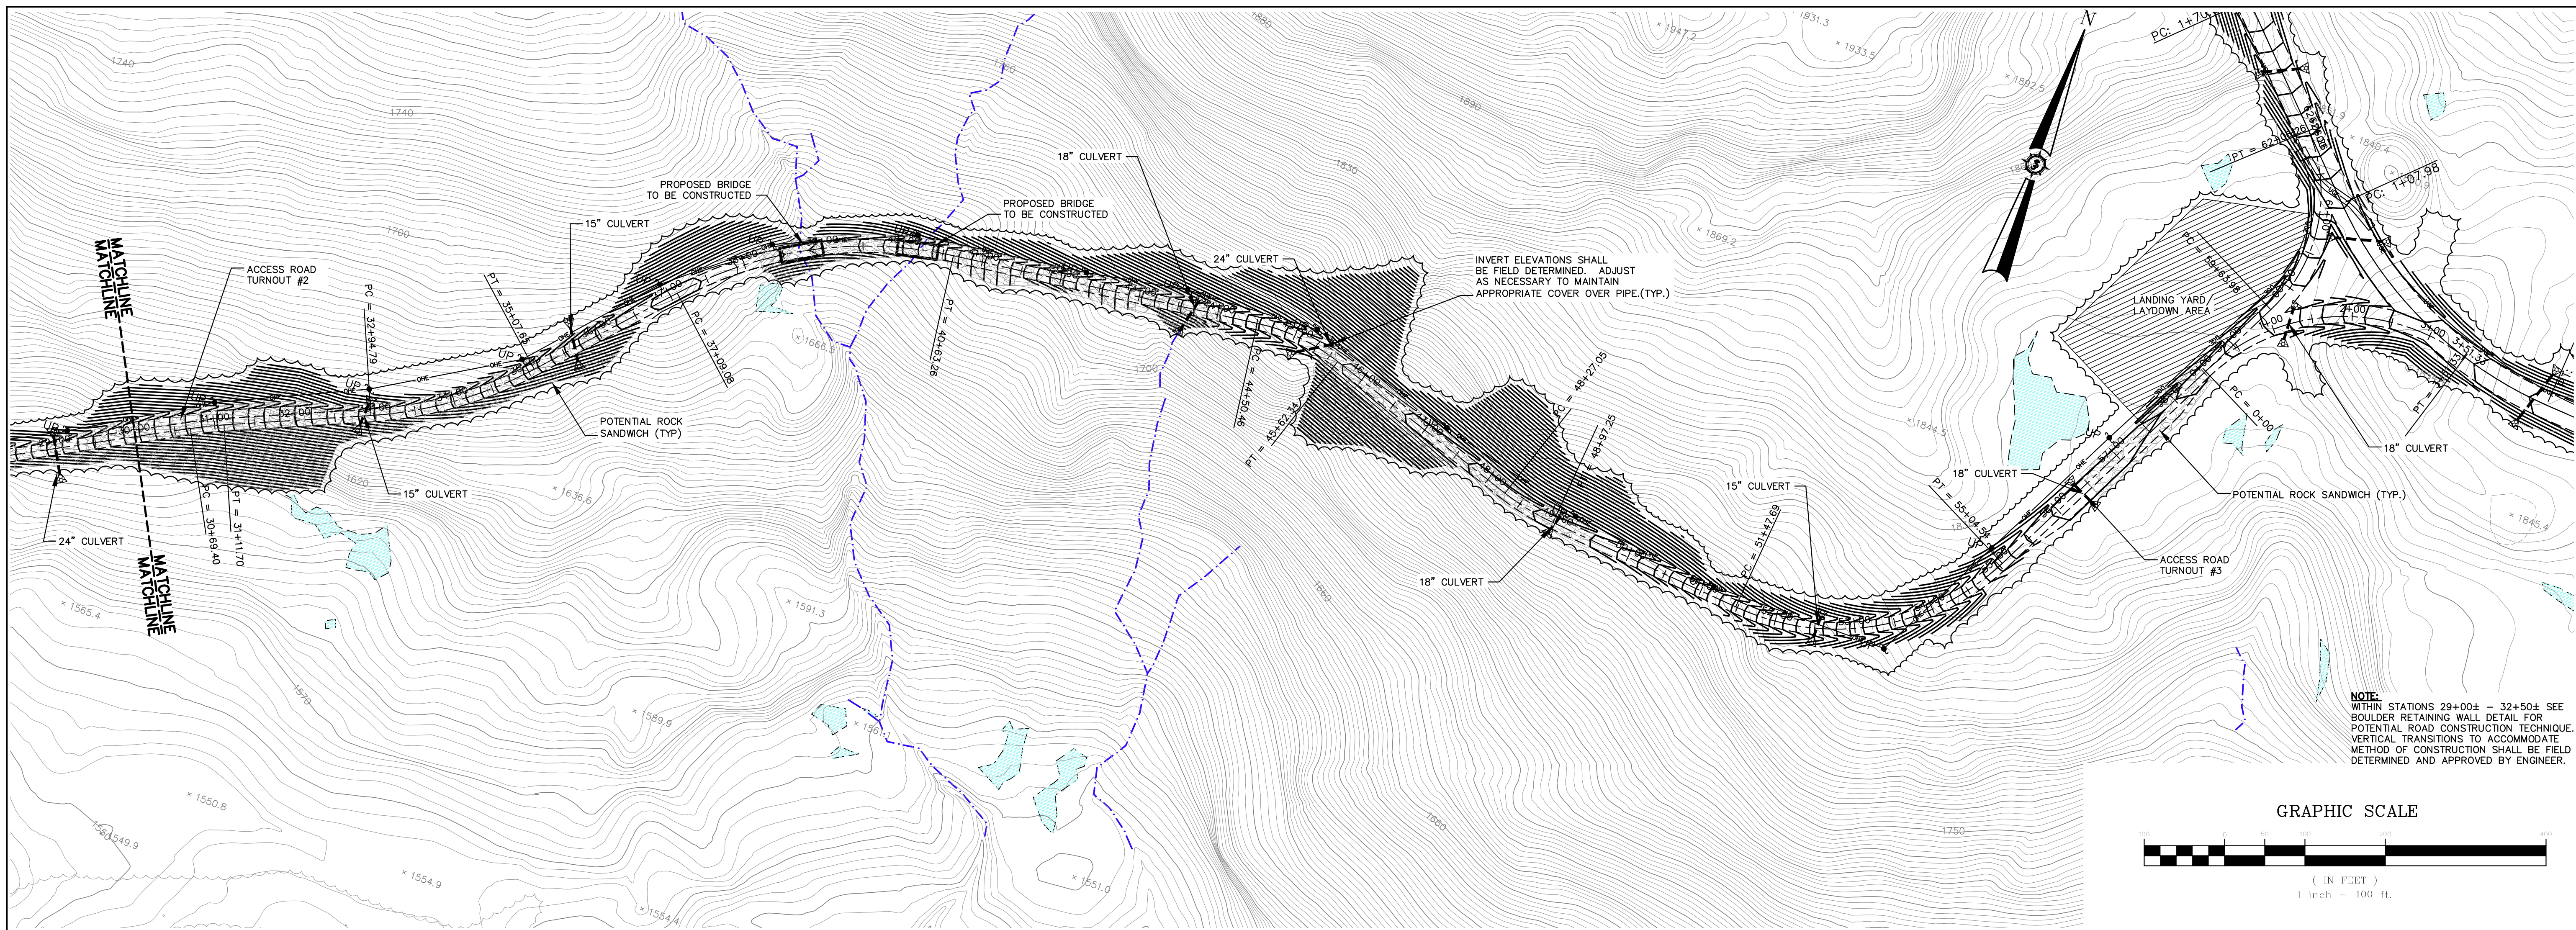

NOTE:
 WITHIN STATIONS 29+00± - 32+50± SEE BOULDER RETAINING WALL DETAIL FOR POTENTIAL ROCK SANDWICH CONSTRUCTION TECHNIQUE. VERTICAL TRANSITIONS TO ACCOMMODATE METHOD OF CONSTRUCTION SHALL BE FIELD DETERMINED AND APPROVED BY ENGINEER.

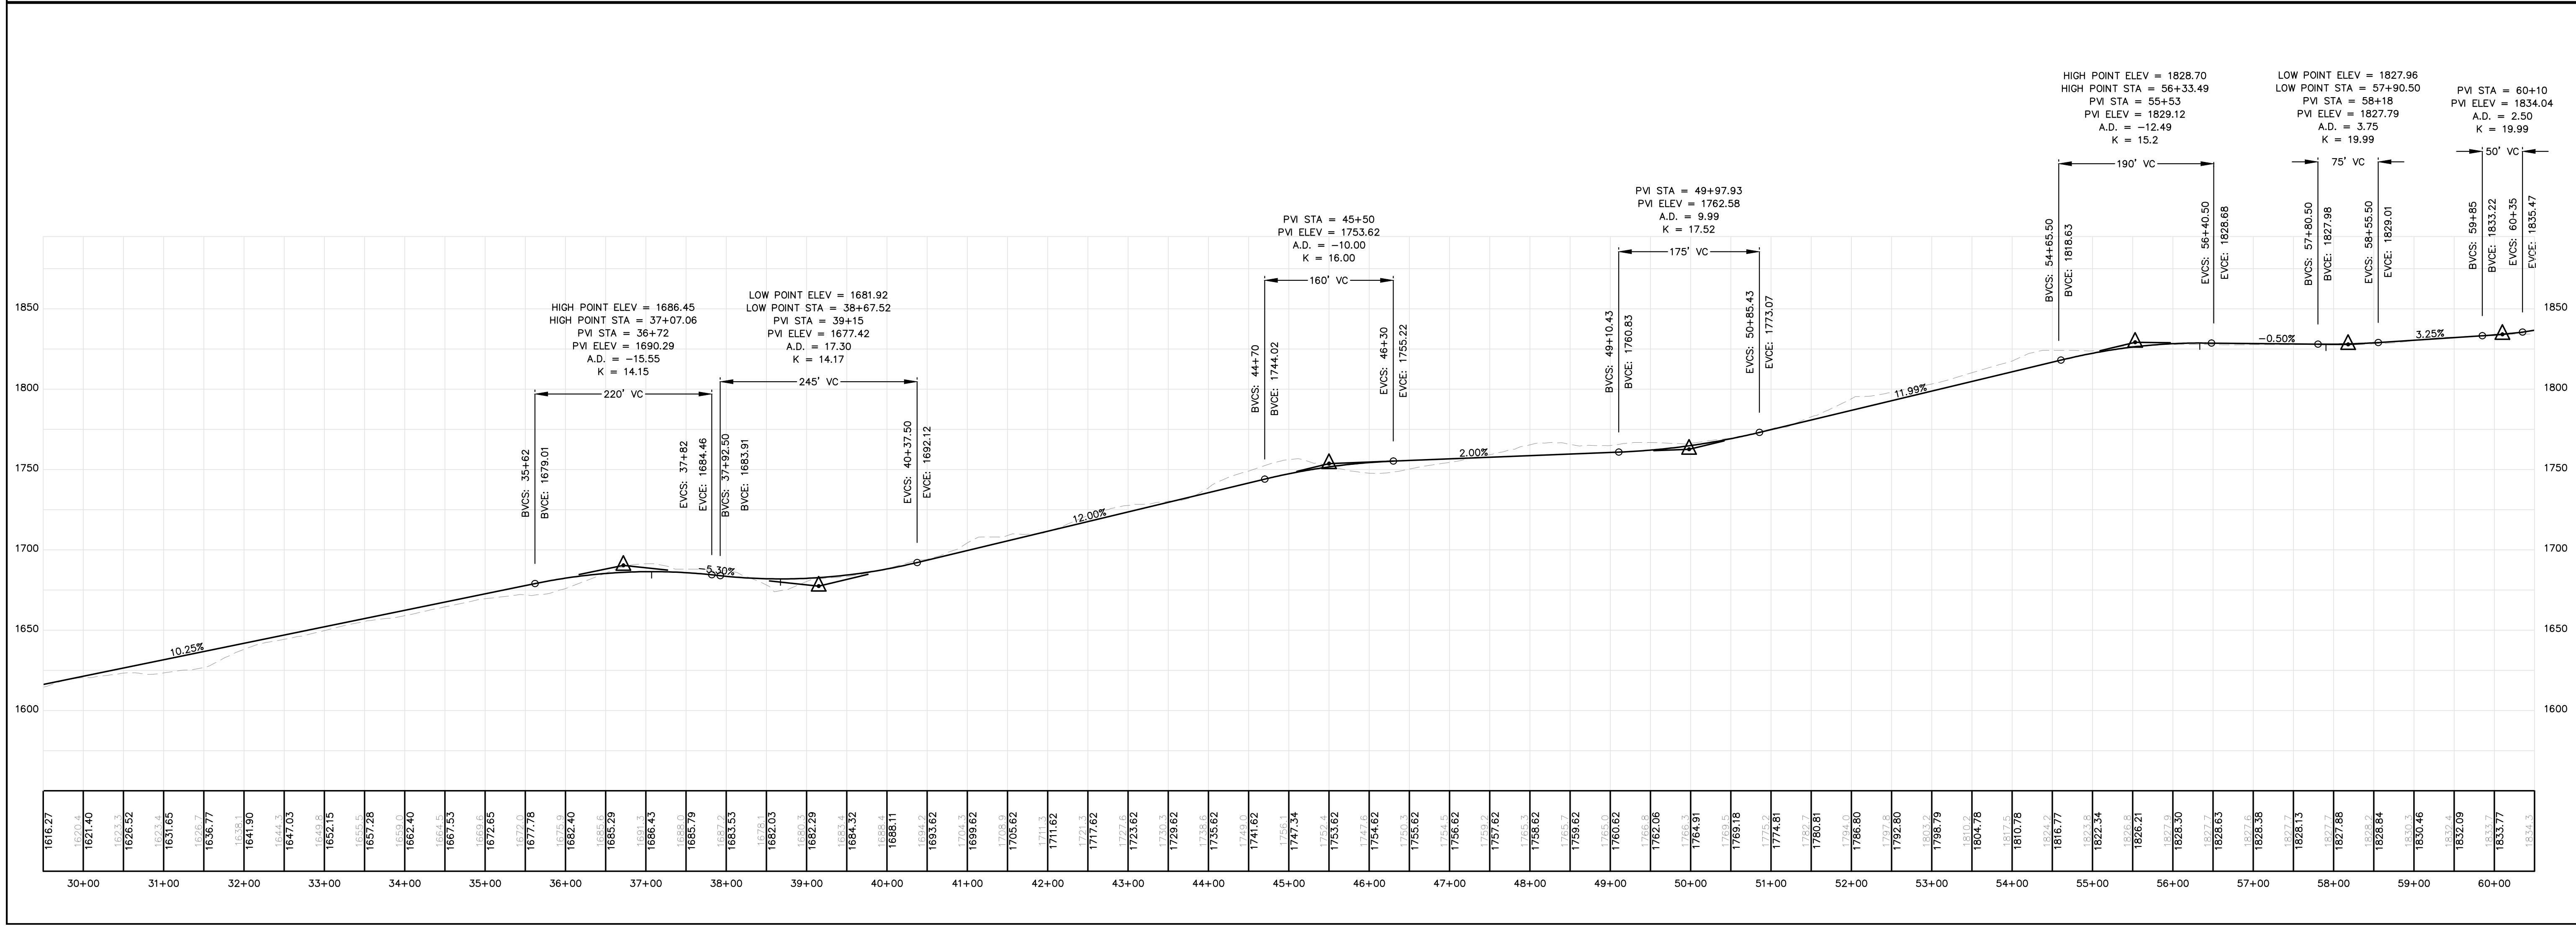

Drawn By	JCH
Checked By	JT
Approved By	BOH

HIGHLAND WIND PROJECT
HIGHLAND WIND LLC


Project Location
 HIGHLAND PLANTATION

Drawing Description
ACCESS ROAD
STA. 30+00 TO 60+00

Scale
 H: 1" = 100' V: 1" = 50'

Checked By
 JT

Approved
 BOH

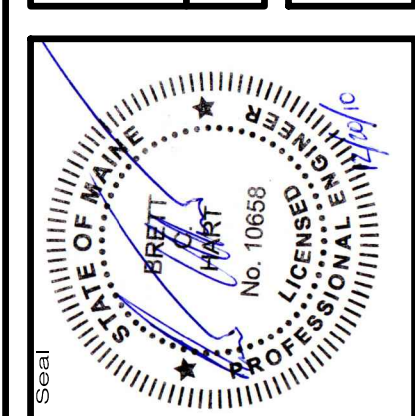

Project No. **66060E**








an integrated team of
 geospatial engineering,
 surveying and NATURAL
 RESOURCE consultants

SEWALL
 JAMES W. SEWALL COMPANY / Since 1880
 SEWALL.COM 800 648 4202

Phase
PERMIT


Sheet No.
C-102

NOT FOR CONSTRUCTION

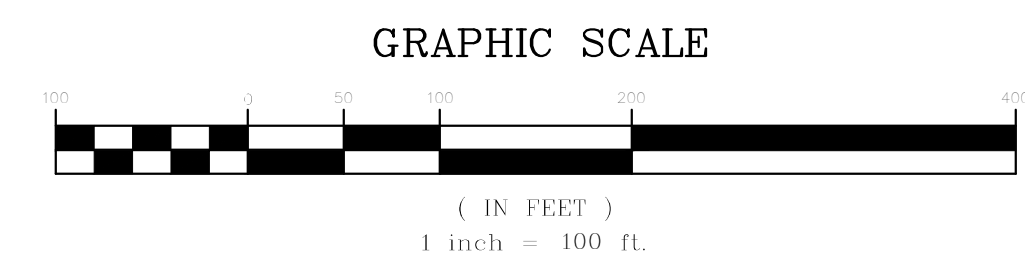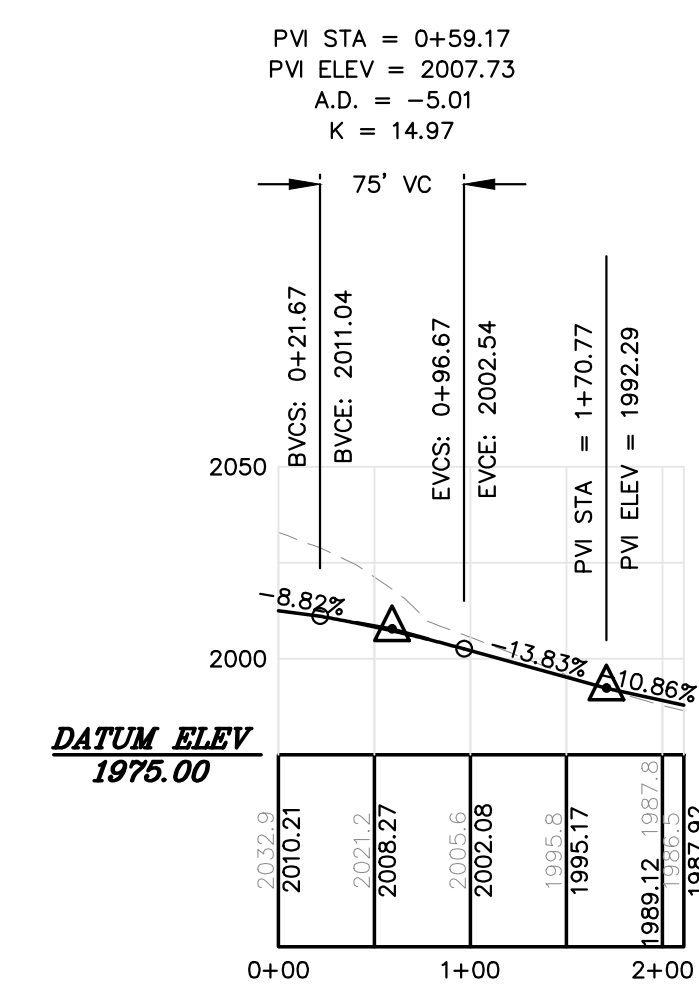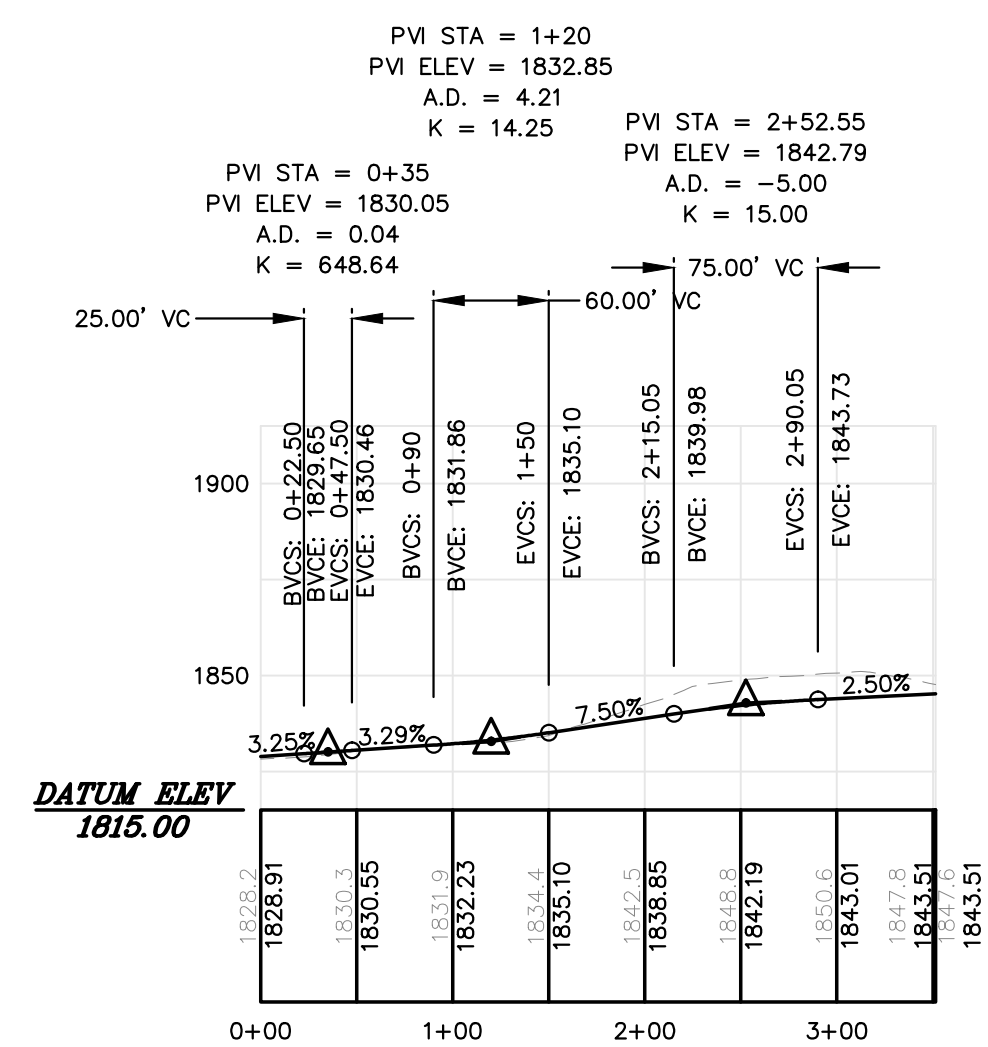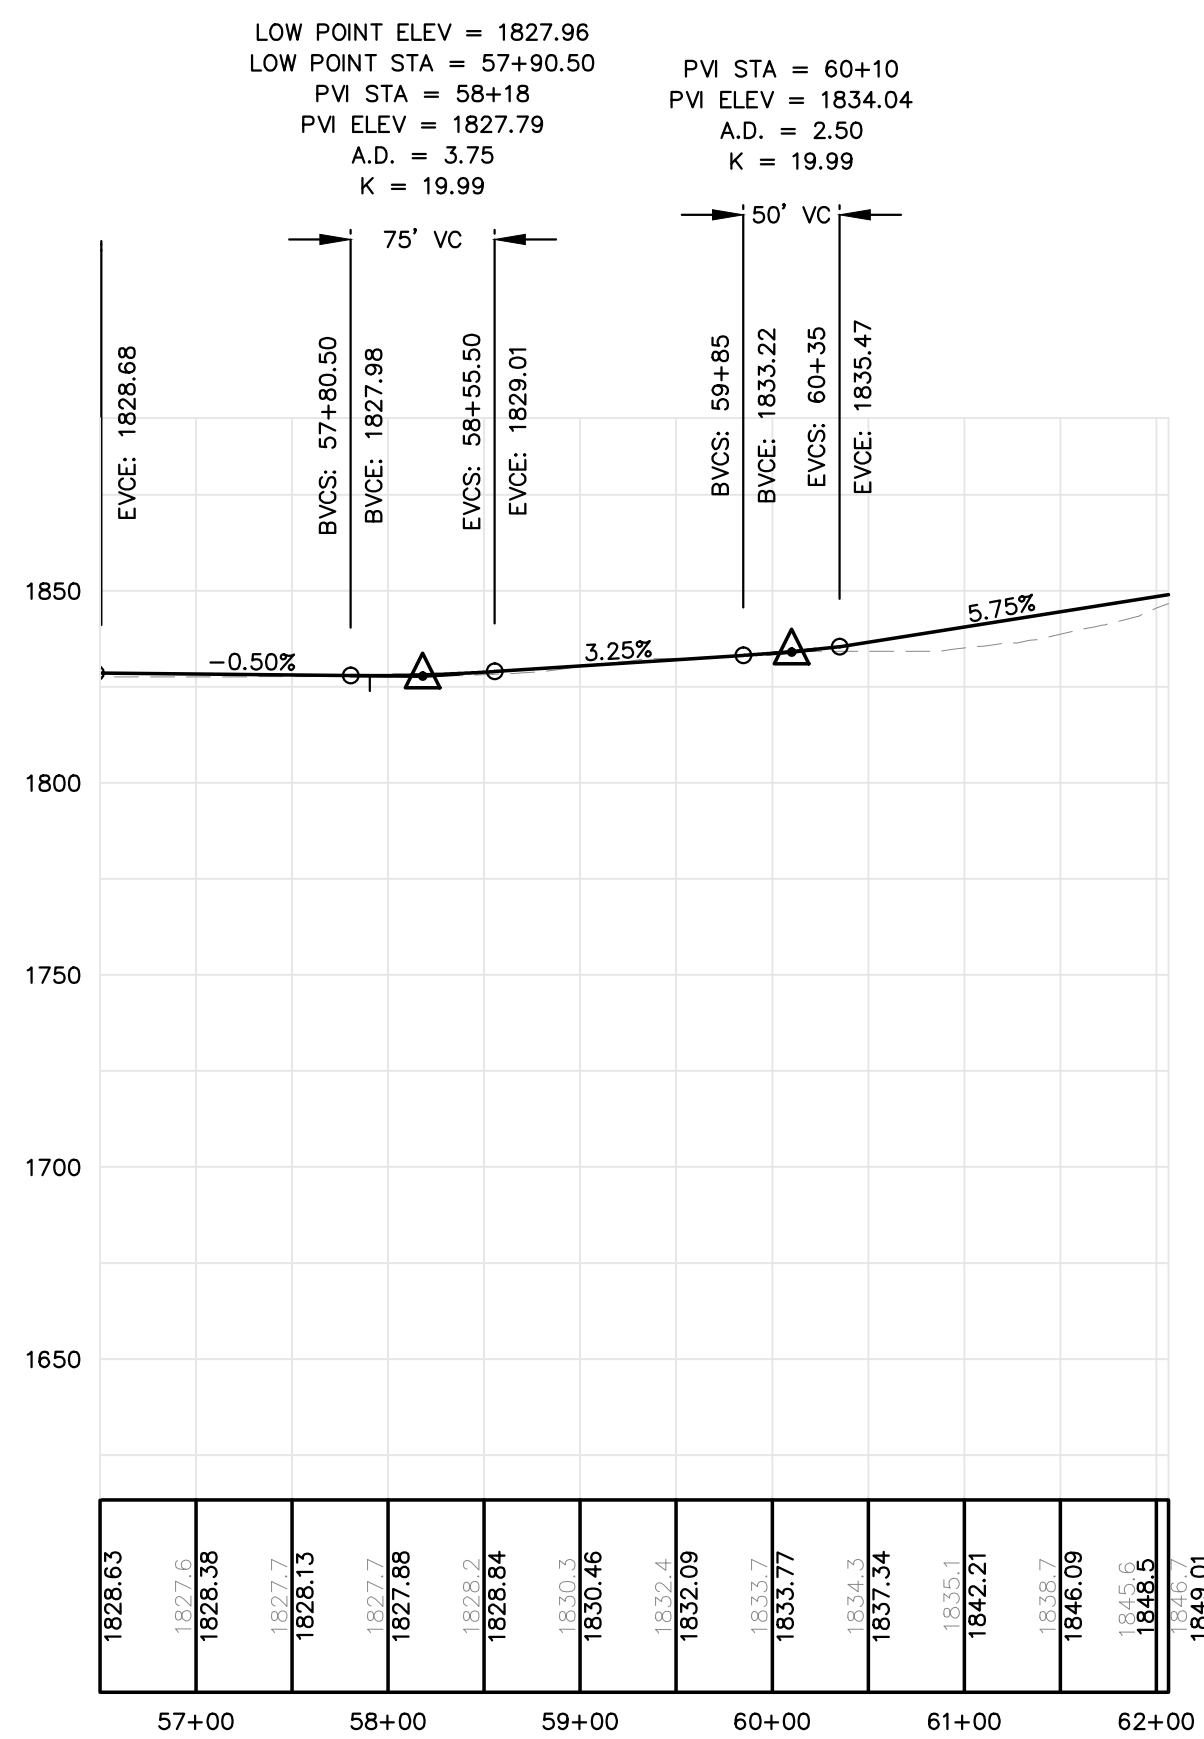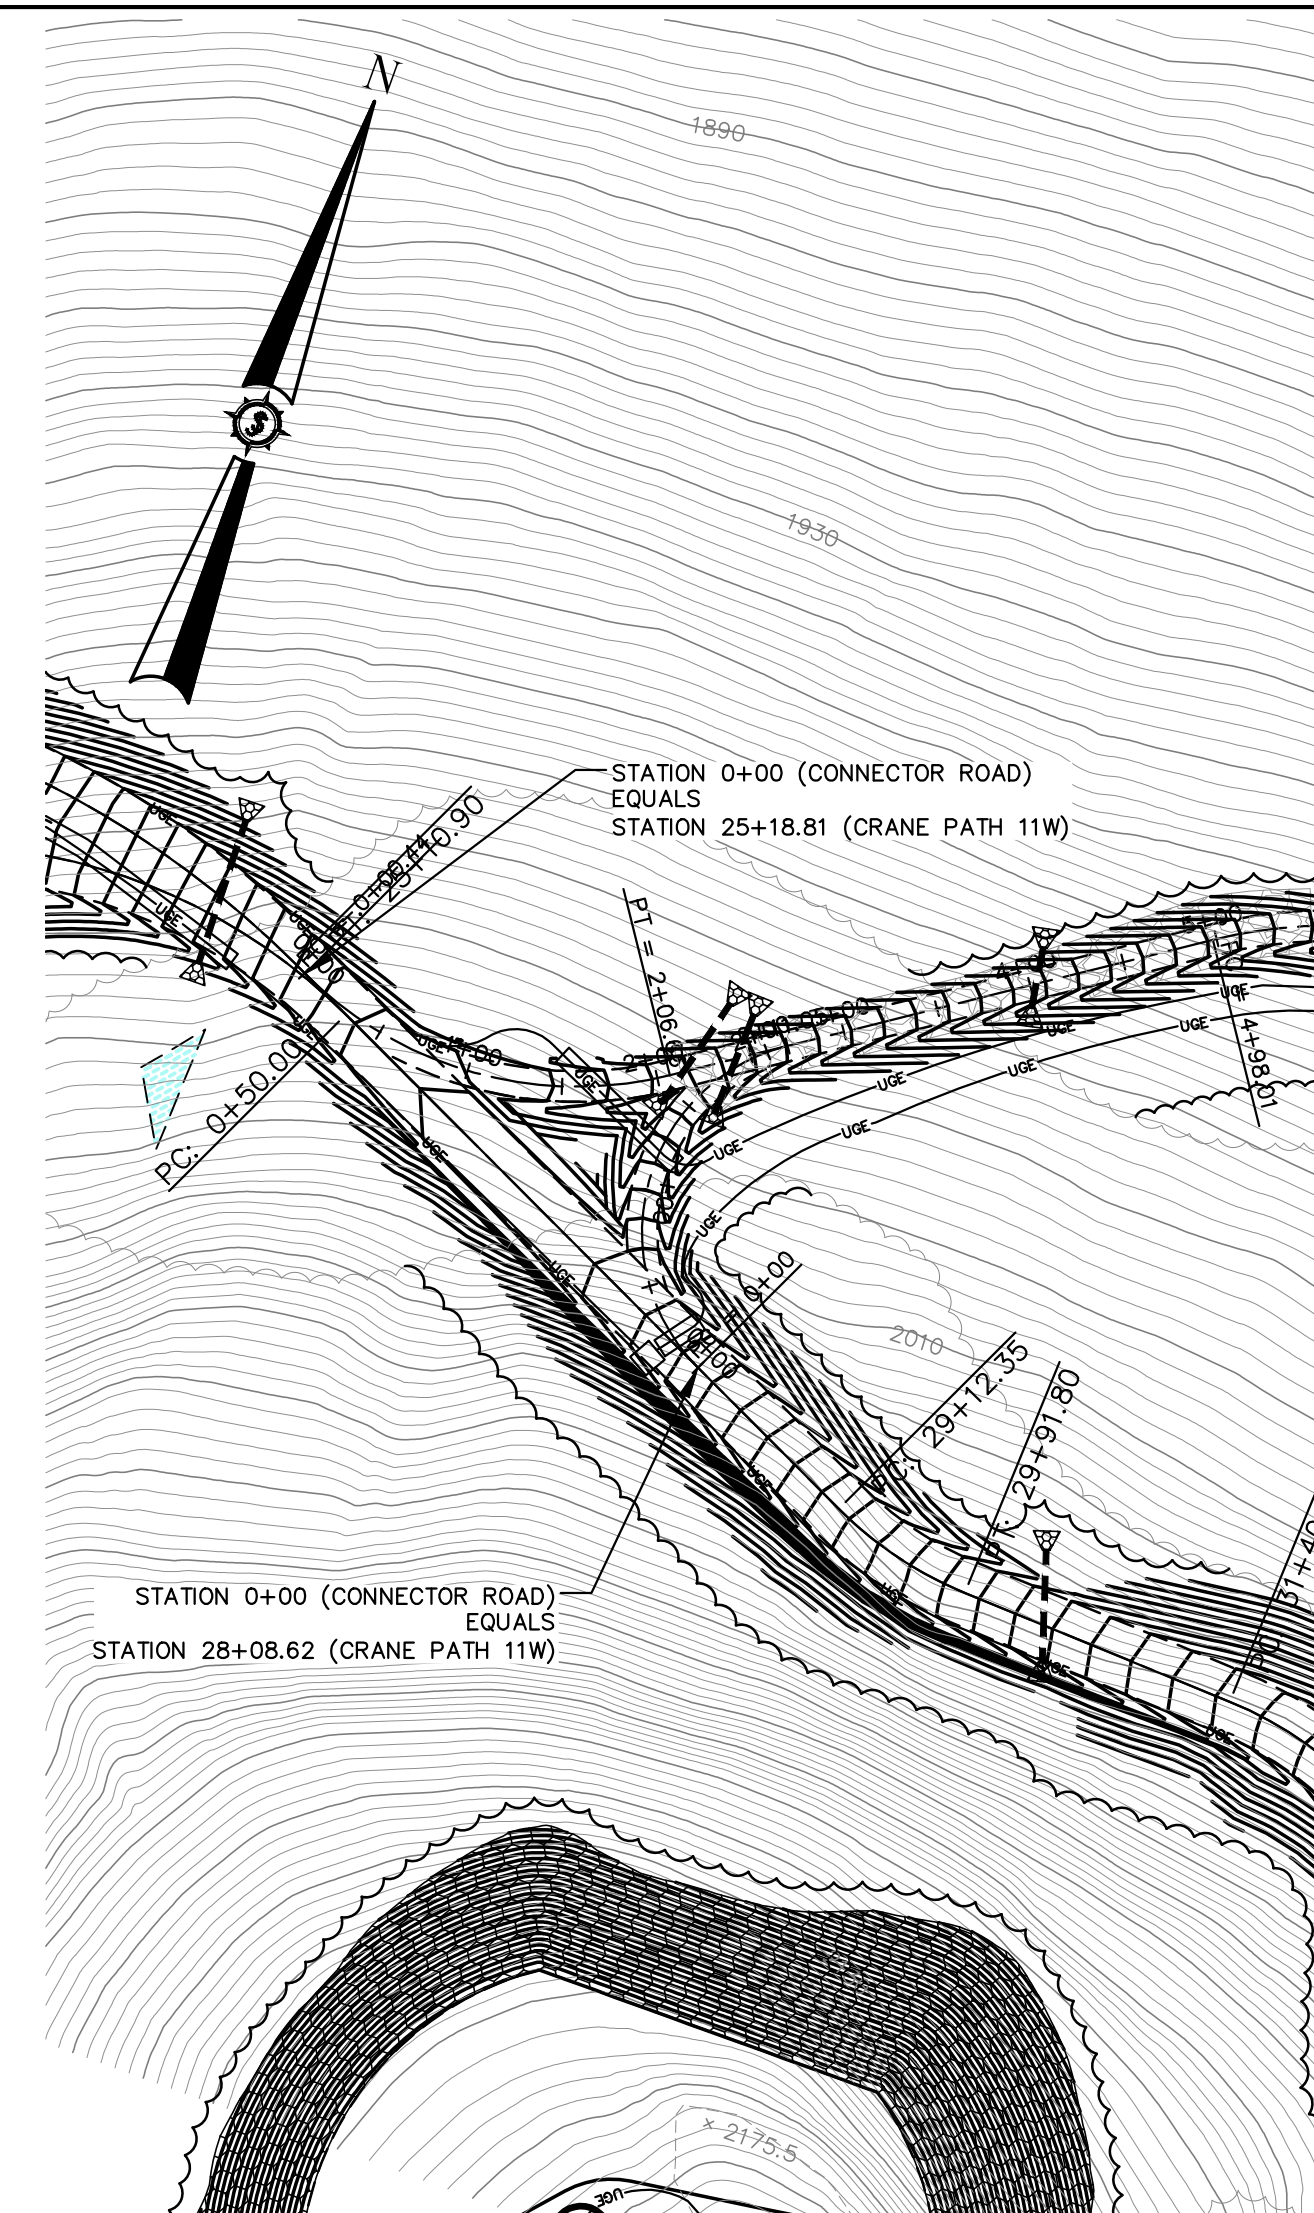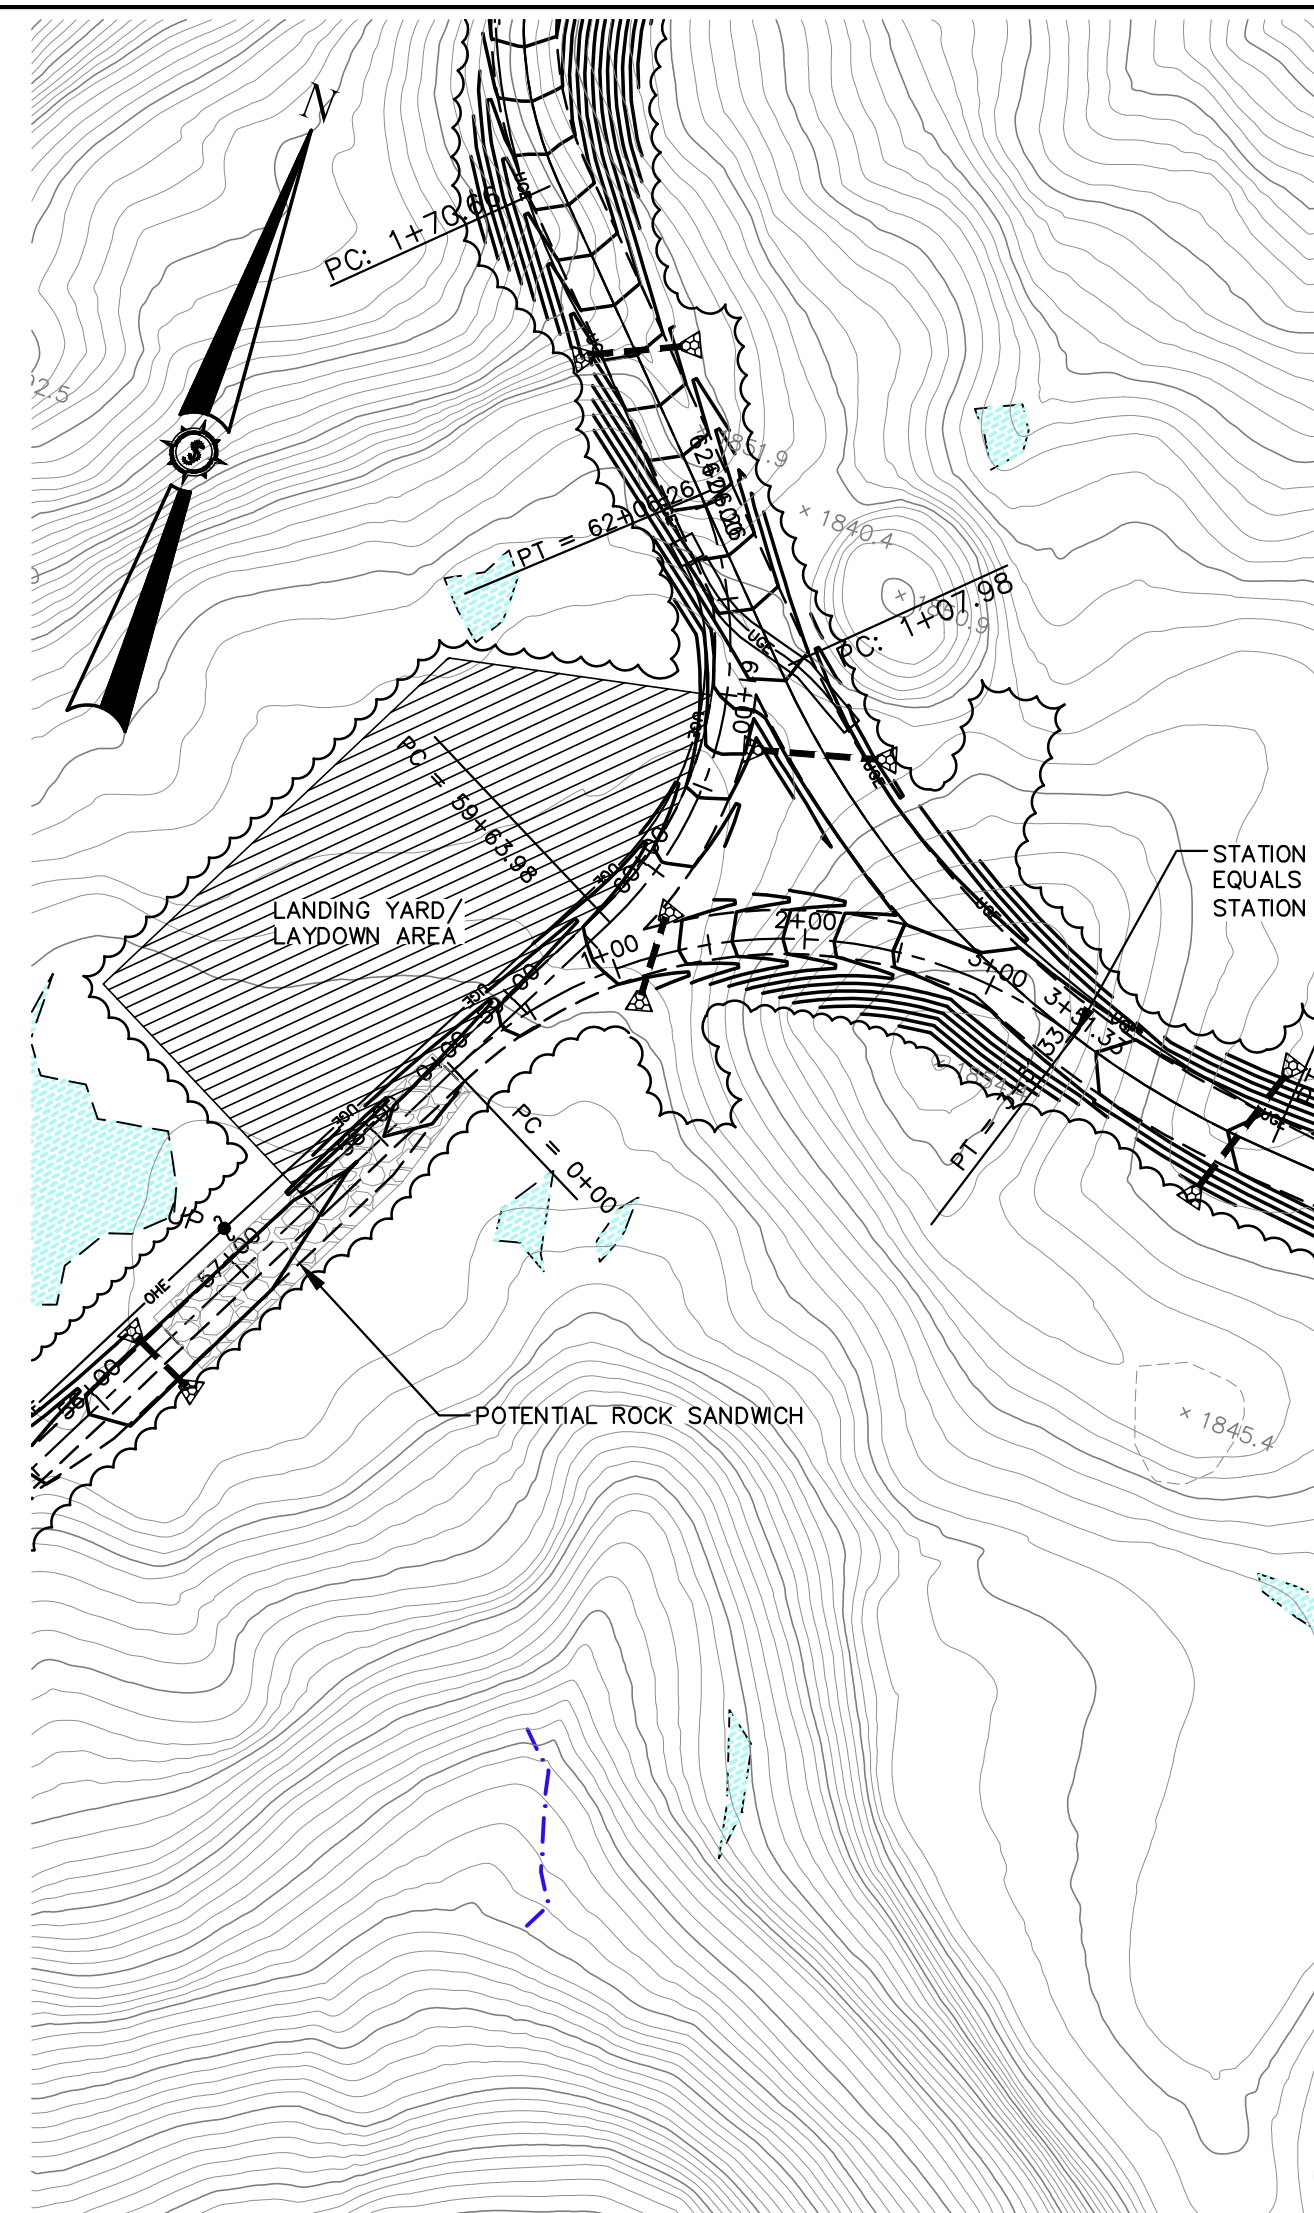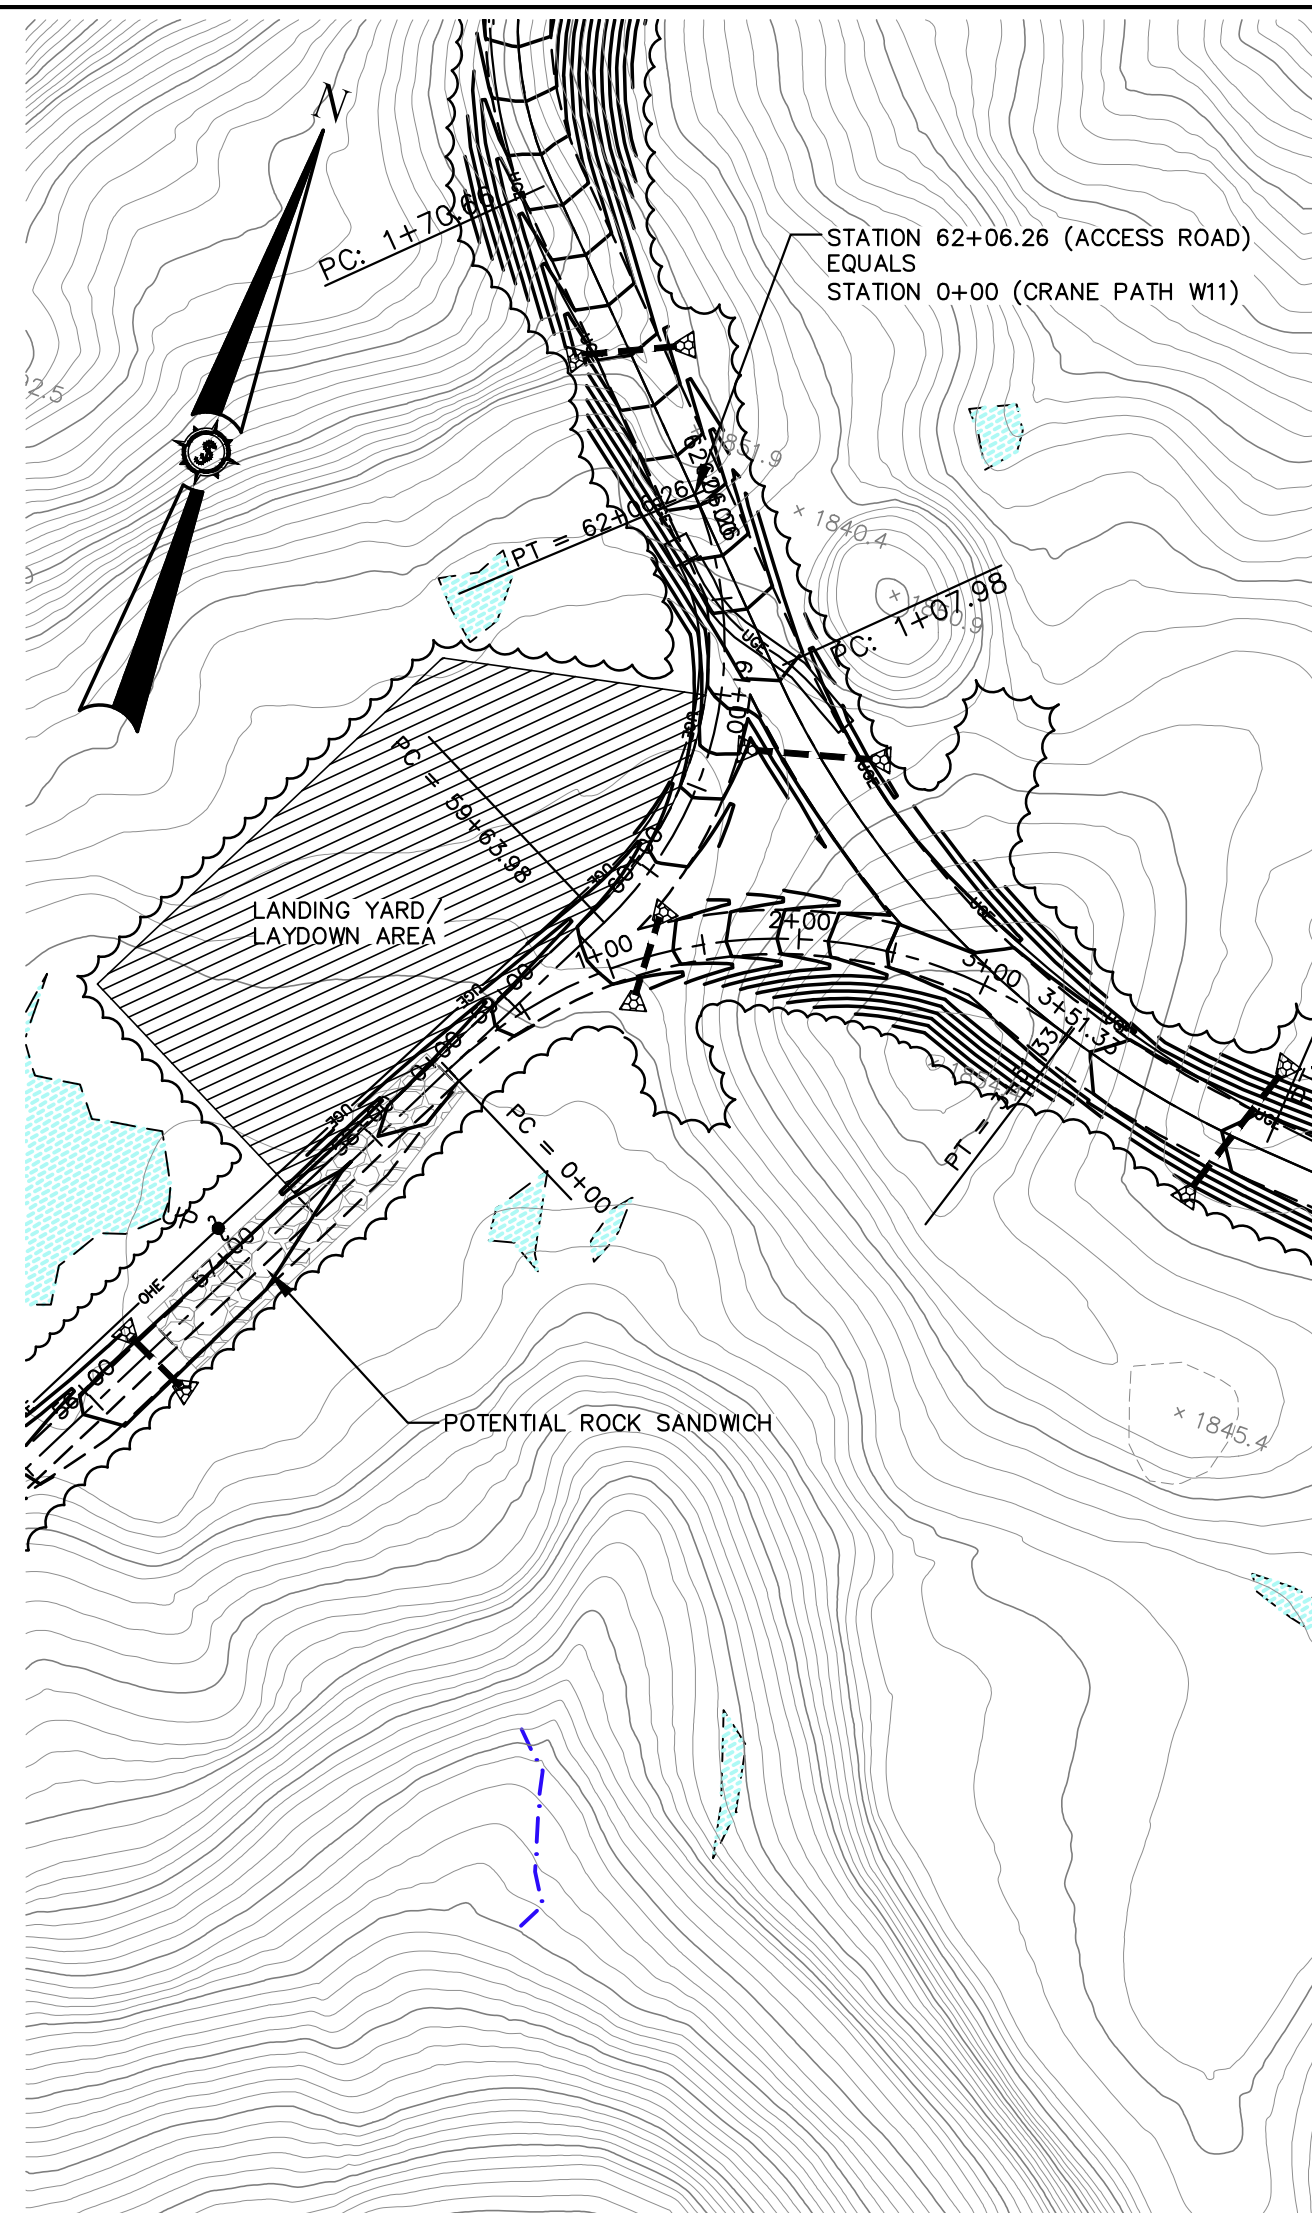

Drawn By	JCH
Checked	JT
Designated By	BOH
Date	12/20/2010
Scale	H: 1"=100' V: 1"=50'
Approved	BOH
Project Location	HIGHLAND PLANTATION
Project Description	ACCESS ROAD STA. 60+00 TO 61+65.25 ACCESS ROAD STUB STA. 0+00 TO 3+51.33

HIGHLAND WIND PROJECT
HIGHLAND WIND LLC
 Project Location: HIGHLAND PLANTATION
 Drawing Description: ACCESS ROAD STA. 60+00 TO 61+65.25
 ACCESS ROAD STUB STA. 0+00 TO 3+51.33


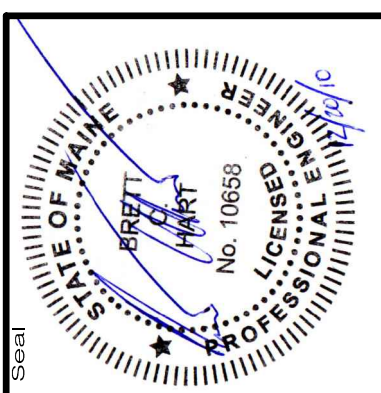


6060E
SEWALL
 JAMES W. SEWALL COMPANY / Since 1881
 SEWALL.COM
 800.646.4202

Project No. 6060E
 Sheet No. **C-103**

PERMIT


NOT FOR CONSTRUCTION

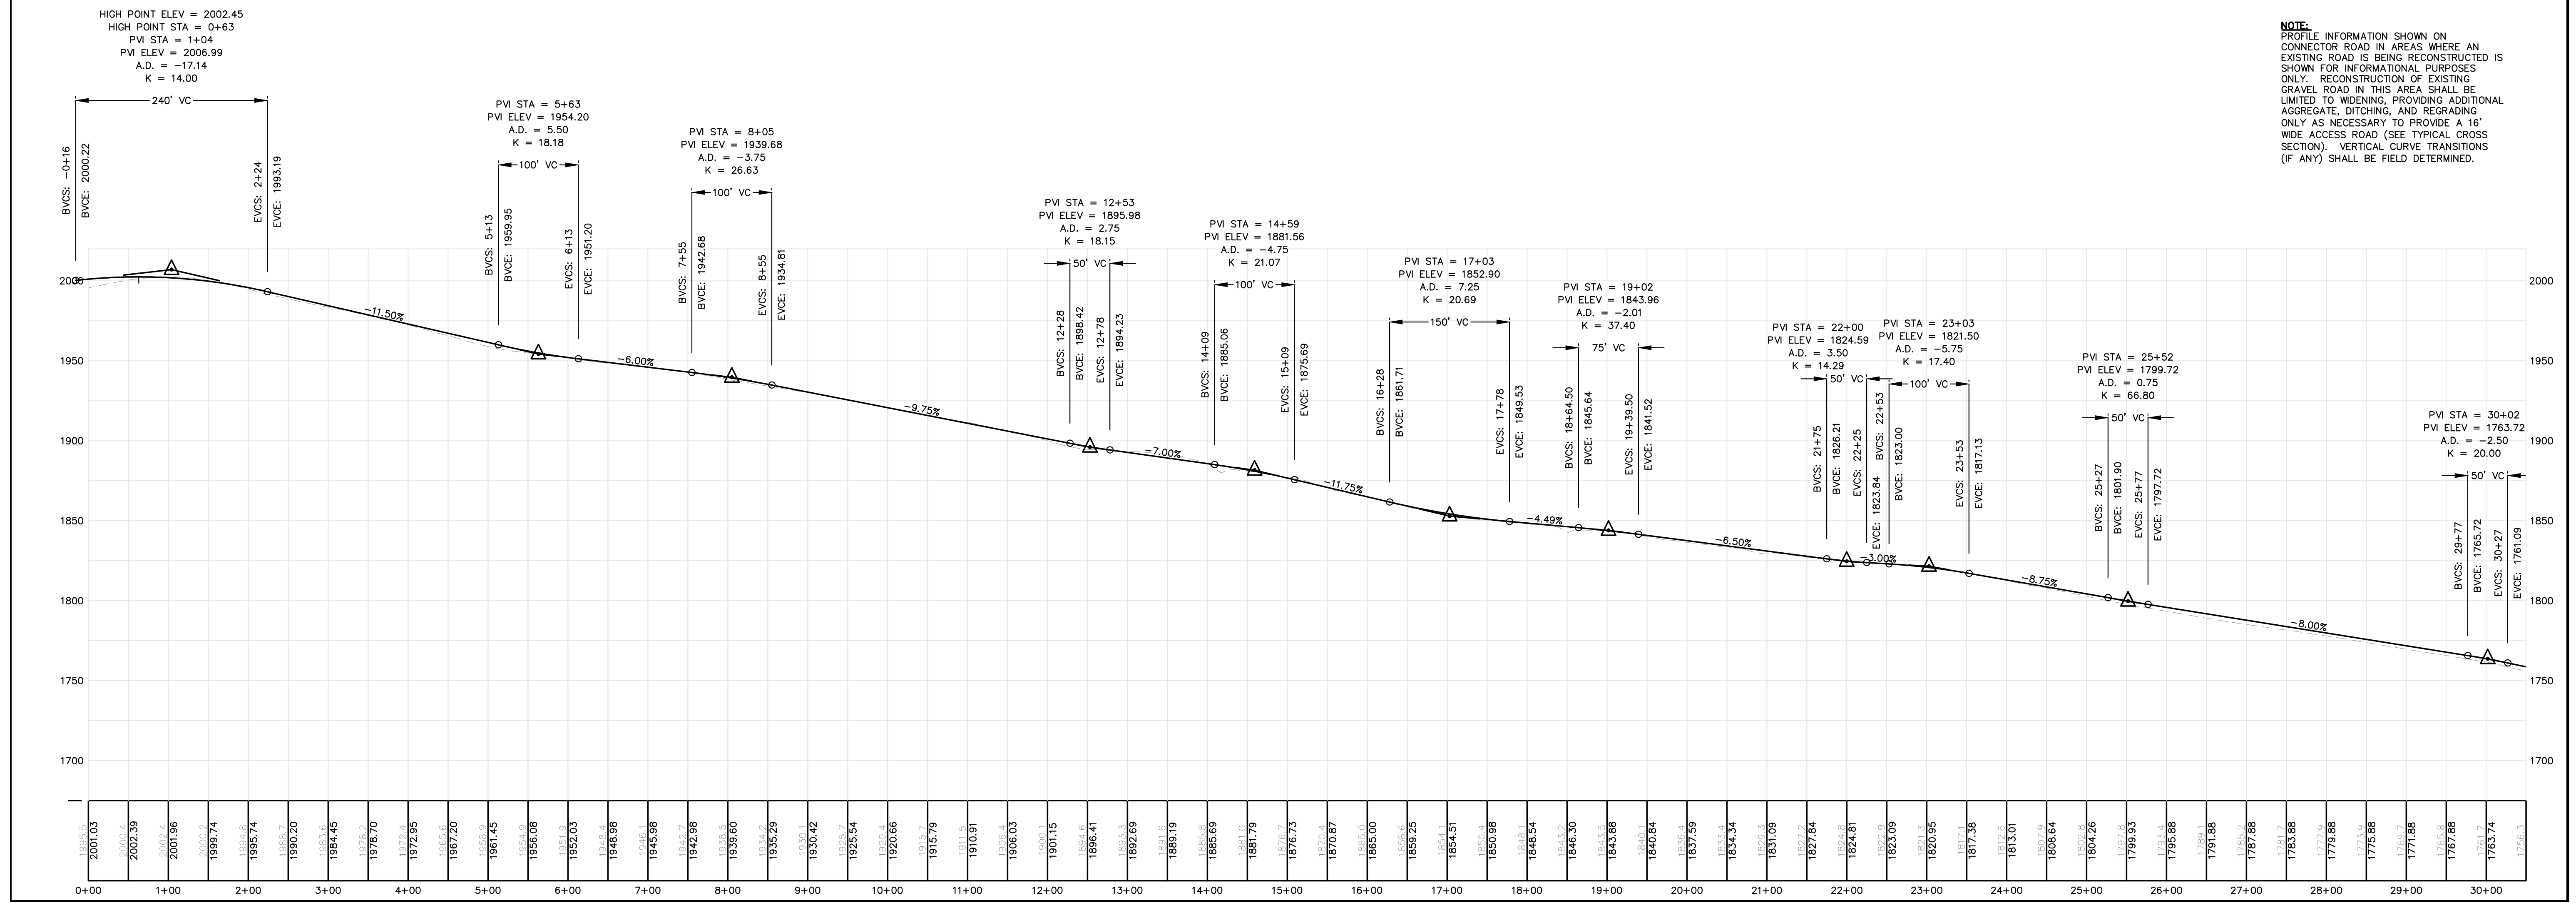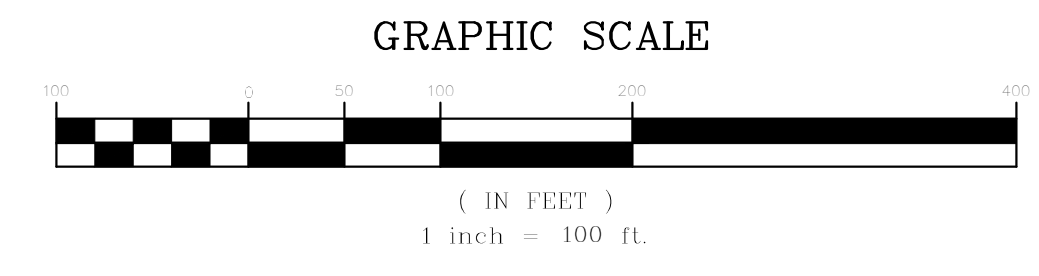

NOTE: PROFILE INFORMATION SHOWN ON CONNECTOR ROAD IN AREAS WHERE AN EXISTING ROAD IS BEING RECONSTRUCTED IS SHOWN FOR INFORMATIONAL PURPOSES ONLY. RECONSTRUCTION OF EXISTING GRAVEL ROAD IN THIS AREA SHALL BE LIMITED TO WIDENING, PROVIDING ADDITIONAL AGGREGATE, DITCHING, AND REGRADING ONLY AS NECESSARY TO PROVIDE A 16' WIDE ACCESS ROAD (SEE TYPICAL CROSS SECTION). VERTICAL CURVE TRANSITIONS (IF ANY) SHALL BE FIELD DETERMINED.





Date	
Drawn By	JCH
Designated By	BOH
Date	12/20/2010
Scale	H: 1"=100' V: 1"=50'
Checked	JT

HIGHLAND WIND PROJECT
HIGHLAND WIND LLC
 Project Location: HIGHLAND PLANTATION
 Scale: H: 1"=100' V: 1"=50'
 Drawing Description: CONNECTOR ROAD STA. 0+00 TO 30+00
 Approved: BOH
 Checked: JT

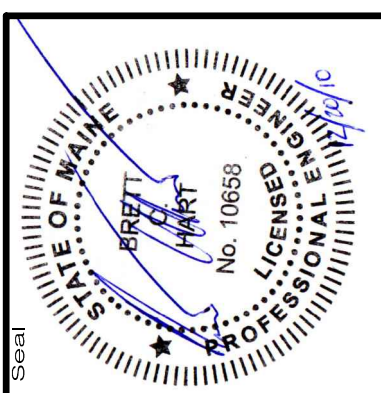


6060E
 on integrated team of geospatial, engineering, planning and natural resource consultants
SEWALL
 JAMES W. SEWALL COMPANY / Since 1881
 800 648 4262
 SEWALL.COM

NOT FOR CONSTRUCTION

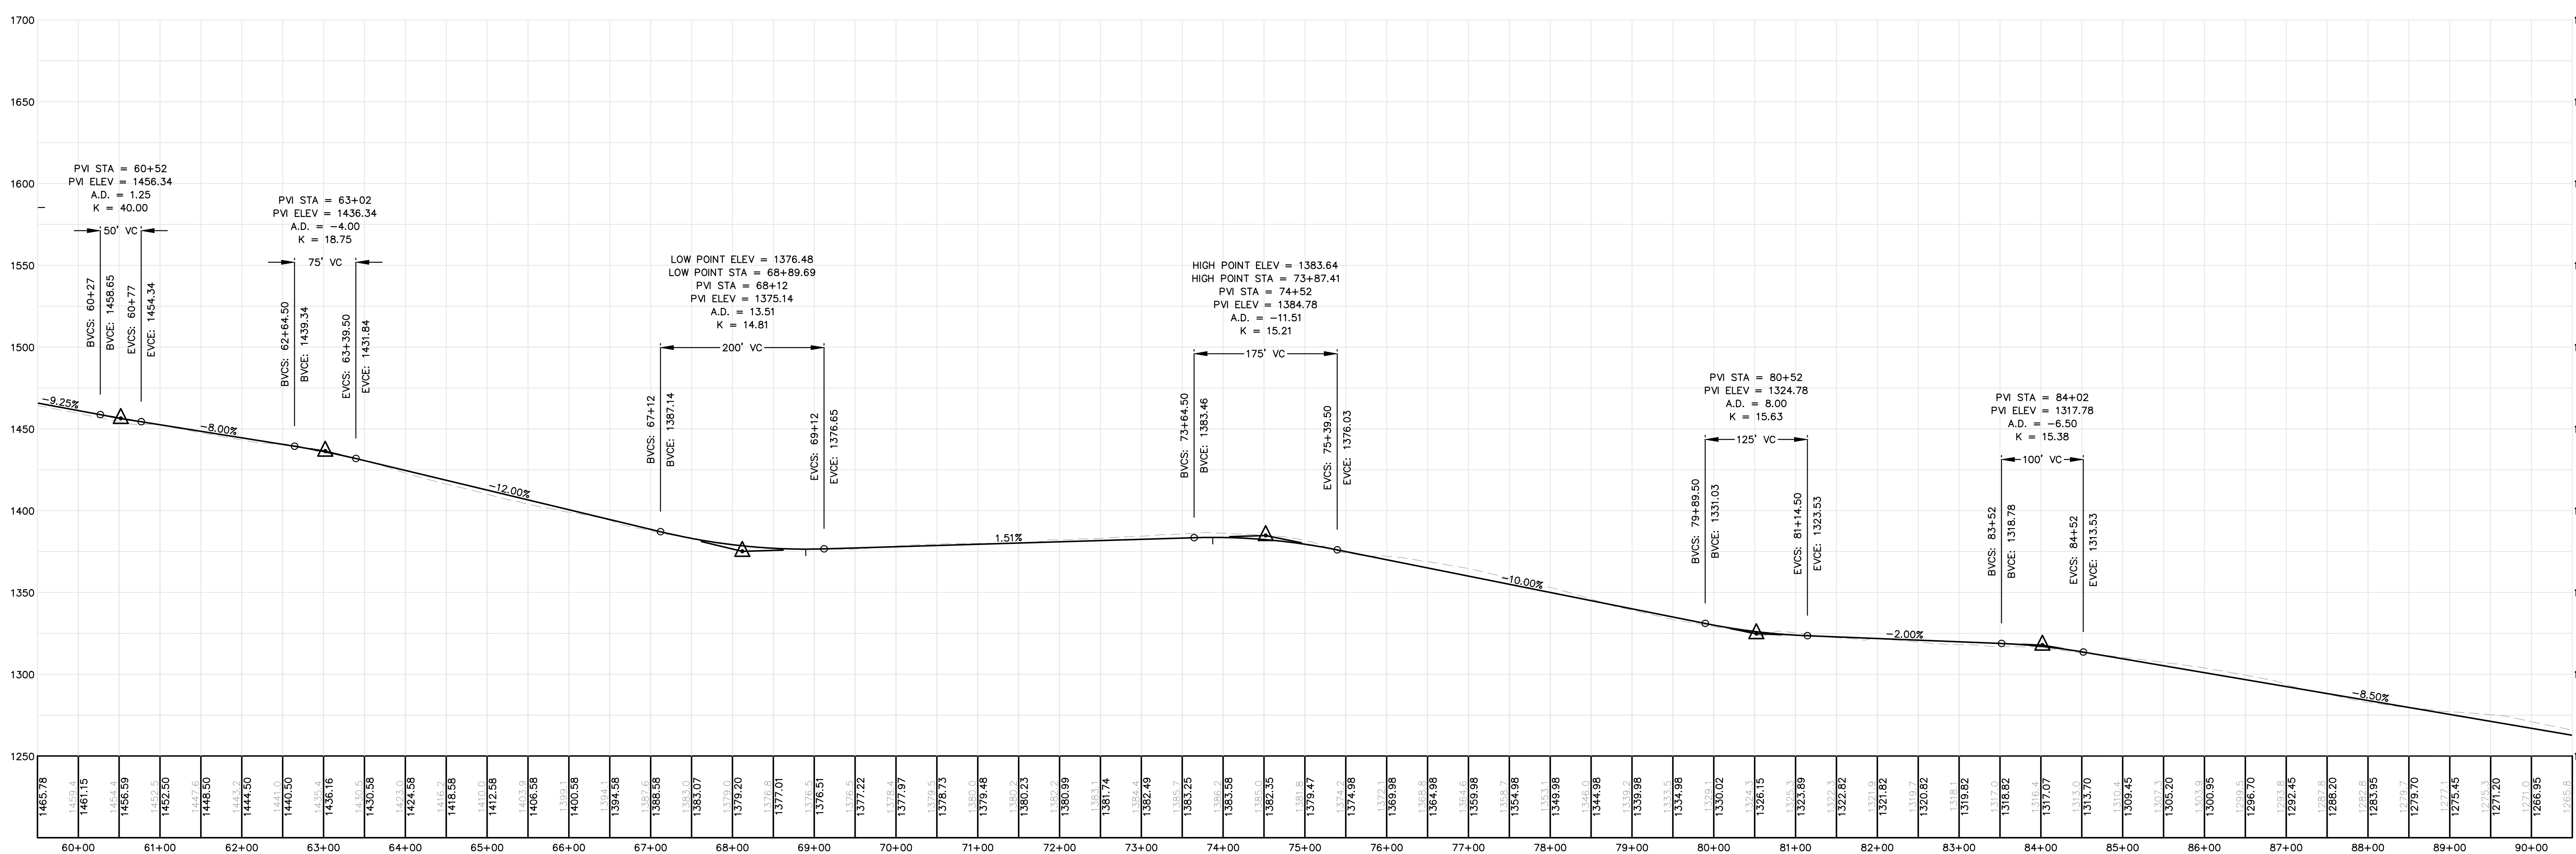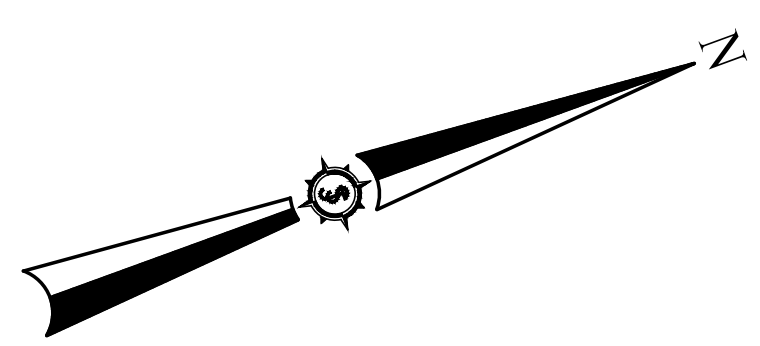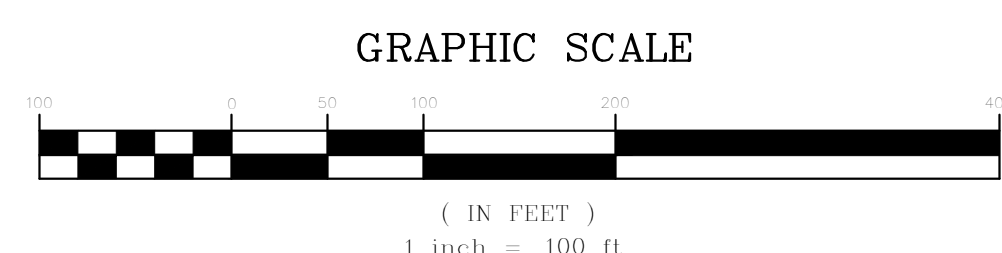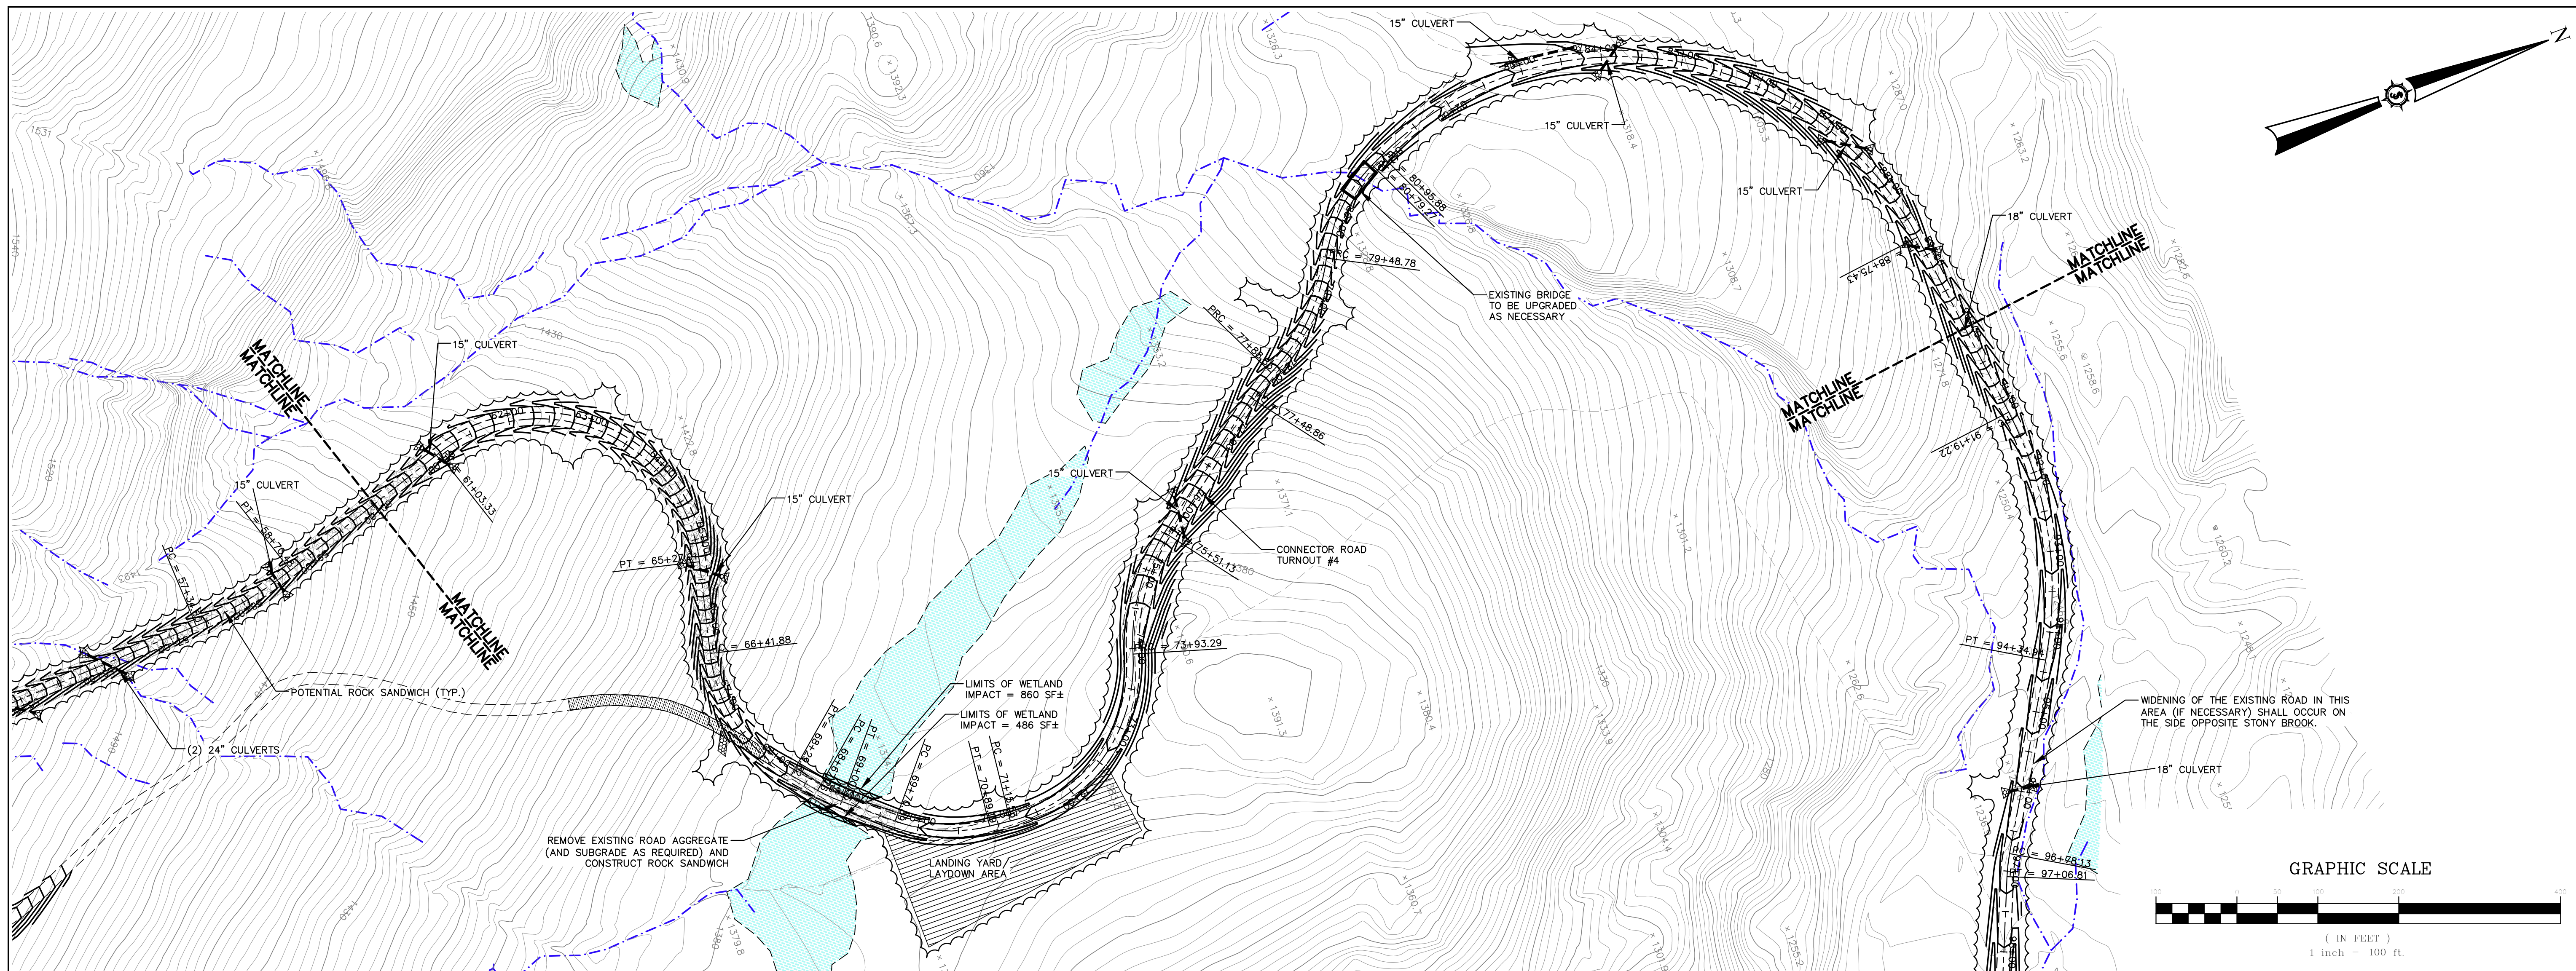

Project No.	60606
Sheet No.	C-106
Project Name	HIGHLAND WIND PROJECT
Project Location	HIGHLAND PLANTATION
Project Description	CONNECTOR ROAD
Stationing	STA. 60+00 TO 90+00
Scale	H: 1"=100' V: 1"=50'
Date	12/20/2010
Drawn By	JCH
Checked	JT
Approved	BOH
Noted	
Revised	
Drawn By	JCH
Checked	JT
Approved	BOH
Noted	
Revised	




HIGHLAND WIND PROJECT
HIGHLAND WIND LLC
 Project Location
 HIGHLAND PLANTATION
 Drawing Description
 CONNECTOR ROAD
 STA. 60+00 TO 90+00
 Scale
 H: 1"=100' V: 1"=50'
 Date
 12/20/2010
 Drawn By
 JCH
 Checked
 JT
 Approved
 BOH

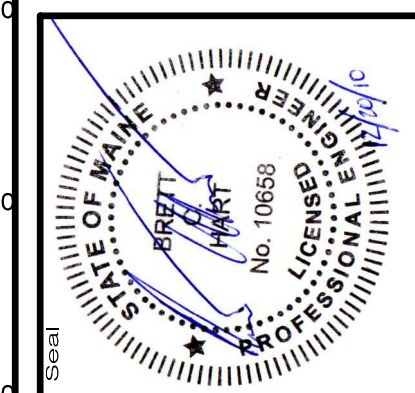

60606
SEWALL
 on integrated team of
 geospatial, engineering,
 surveying and natural
 resource consultants
 JAMES W. SEWALL COMPANY / Since 1881
 SEWALL.COM
 800 648 4202

PERMIT
 Sheet No.
C-106


NOT FOR
CONSTRUCTION

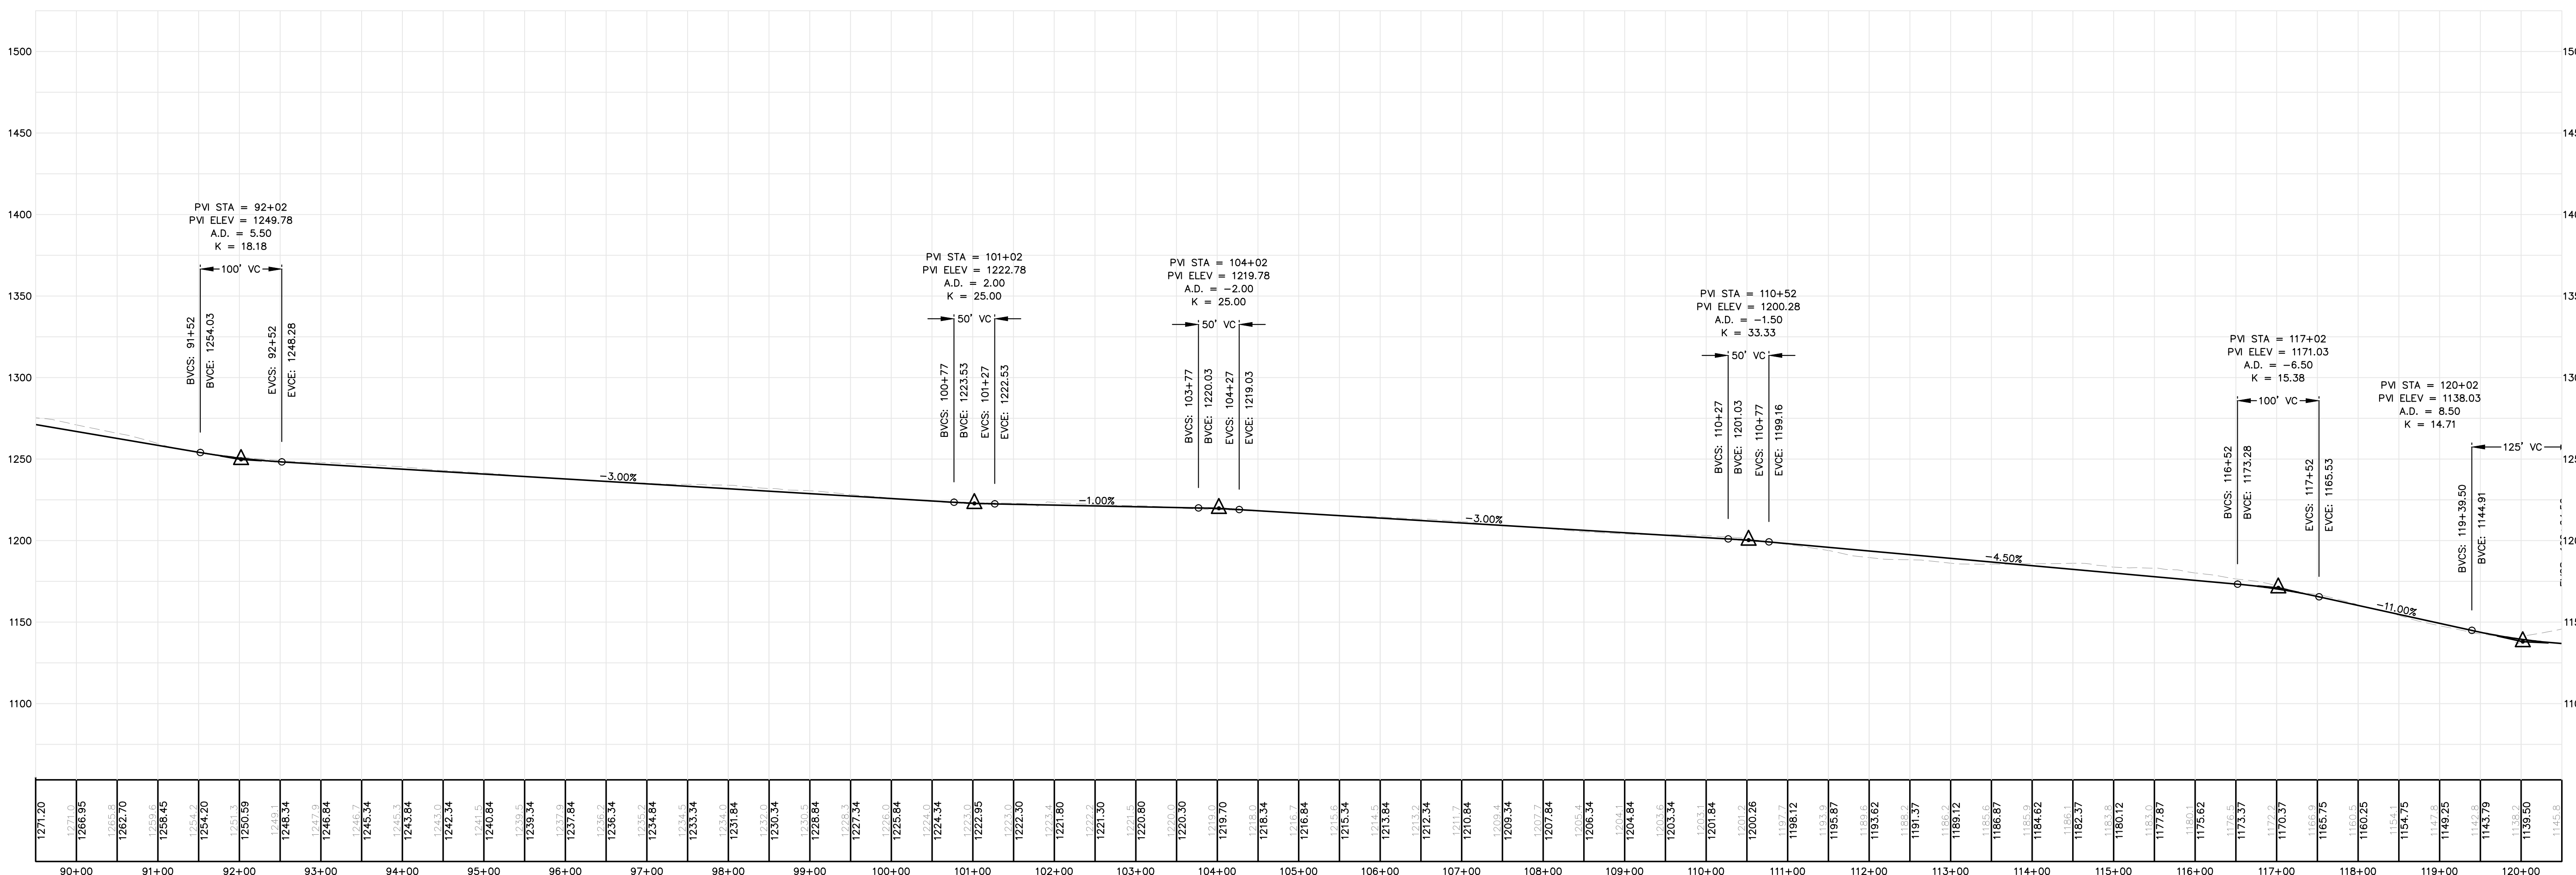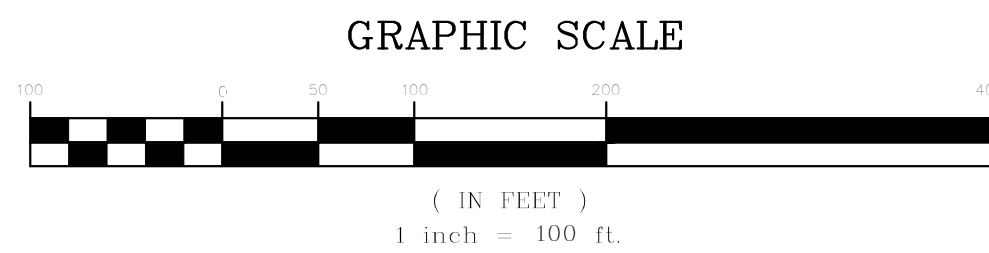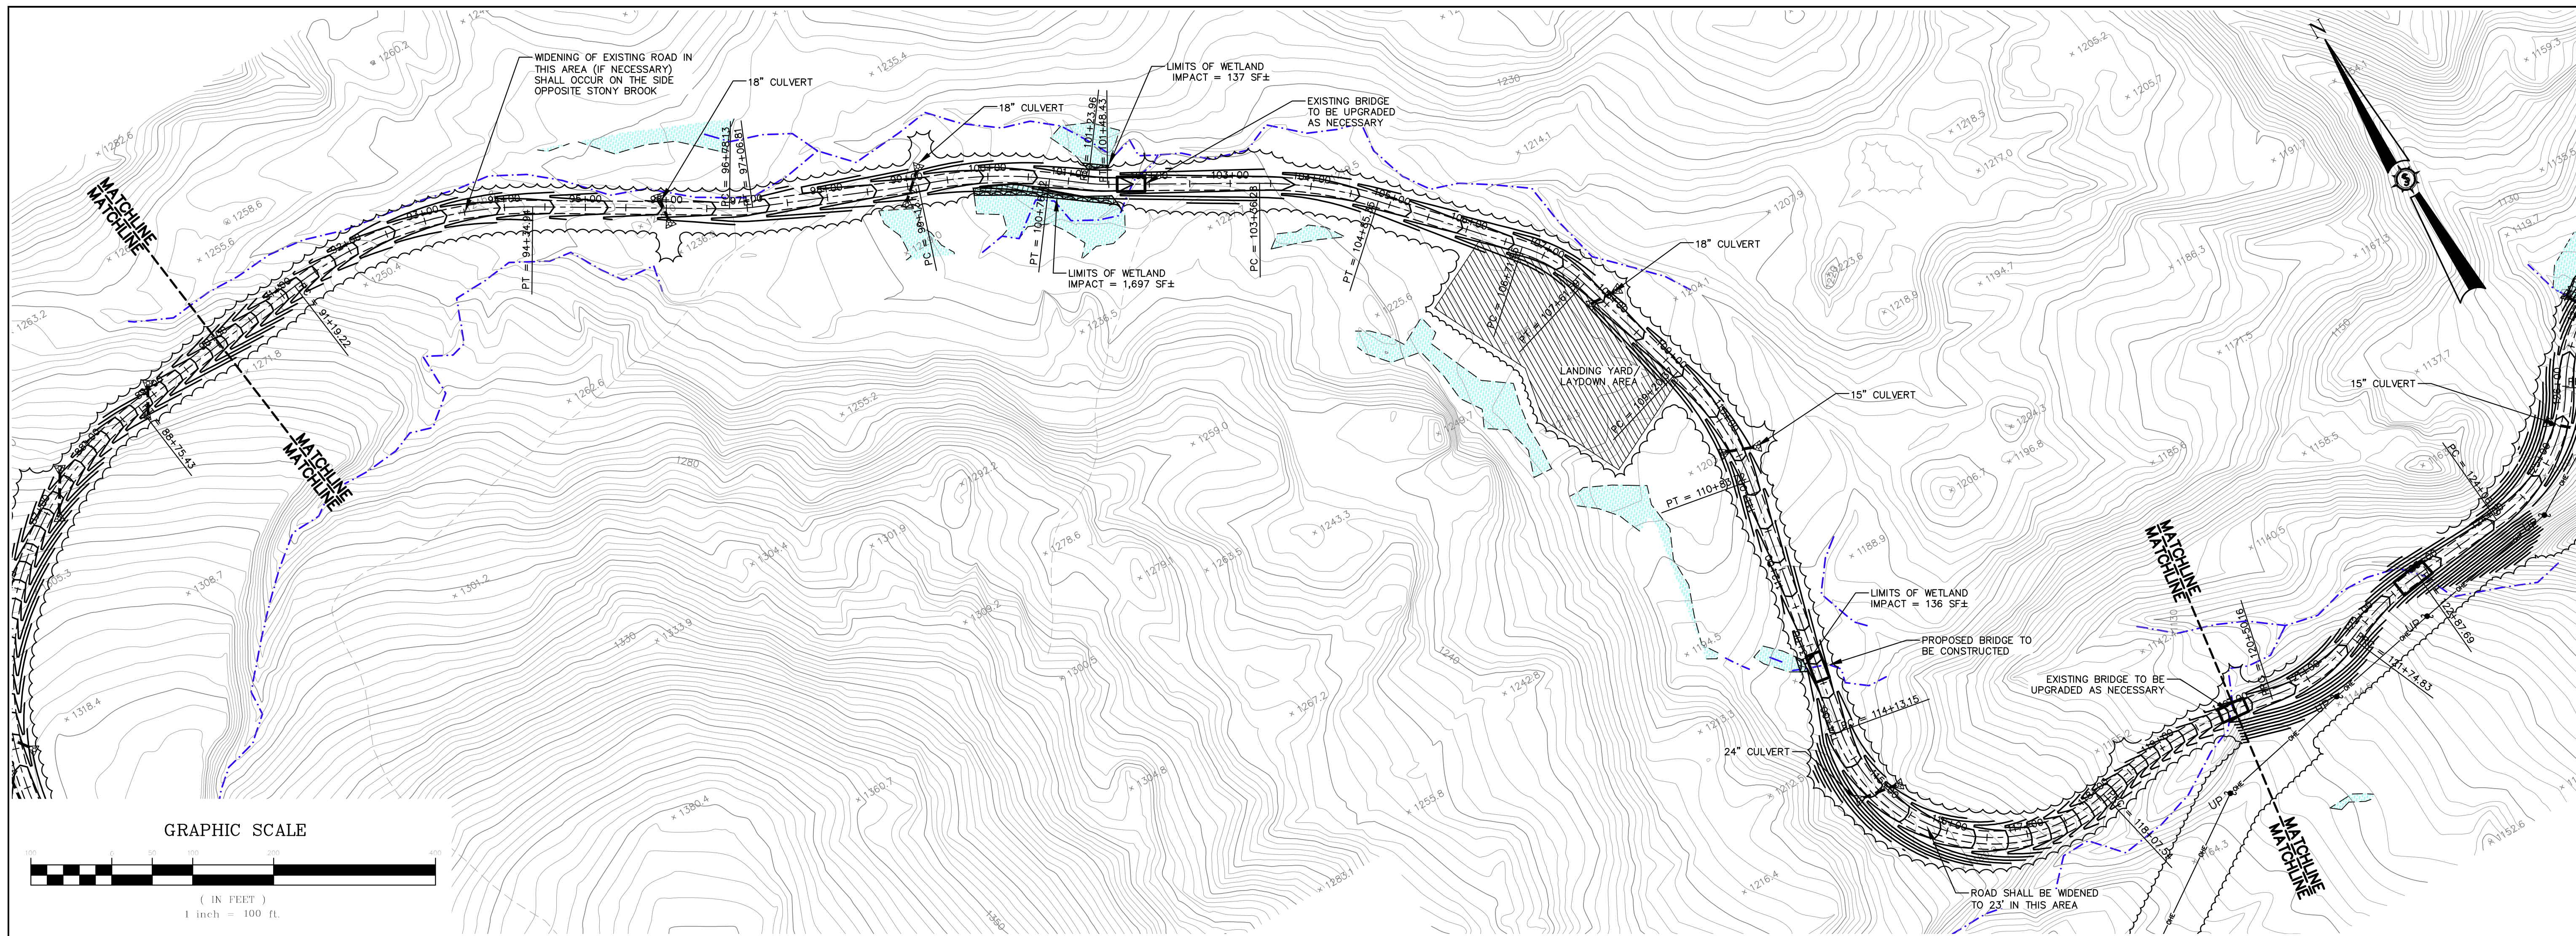

Drawn By	JCH
Designated By	BOH
Date	12/20/2010
Scale	H: 1"=100' V: 1"=50'
Checked	JT

HIGHLAND WIND PROJECT
HIGHLAND WIND LLC
 Project Location
 HIGHLAND PLANTATION
 CONNECTOR ROAD
 STA. 90+00 TO 120+00

Approved
 BOH


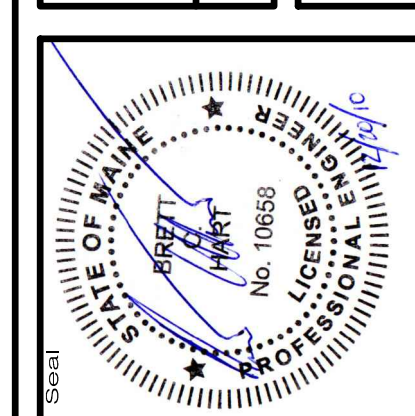


6060E

an integrated team of
 geospatial, engineering,
 surveying and natural
 resource consultants

SEWALL
 JAMES W. SEWALL COMPANY / Since 1881
 SEWALL.COM
 800.648.4262

NOT FOR
CONSTRUCTION

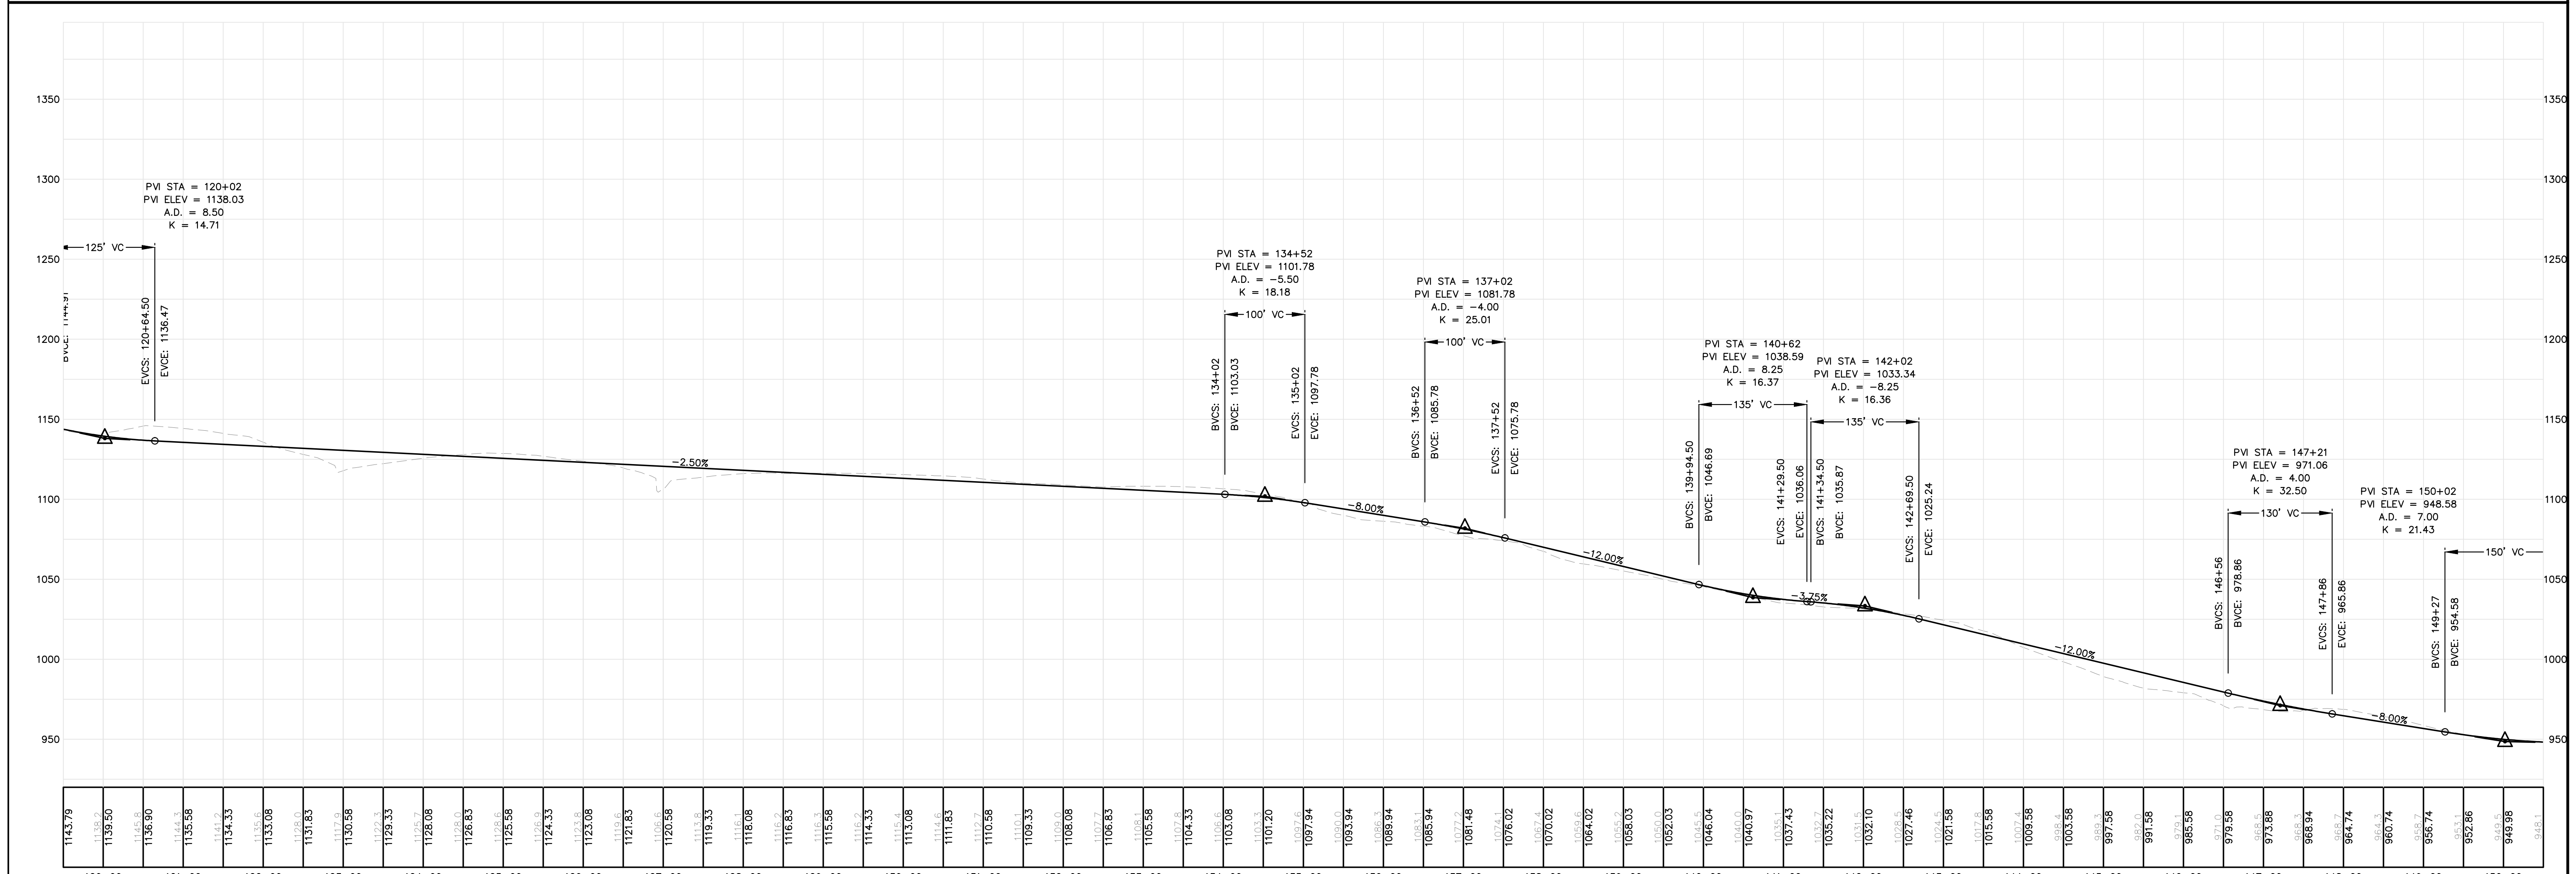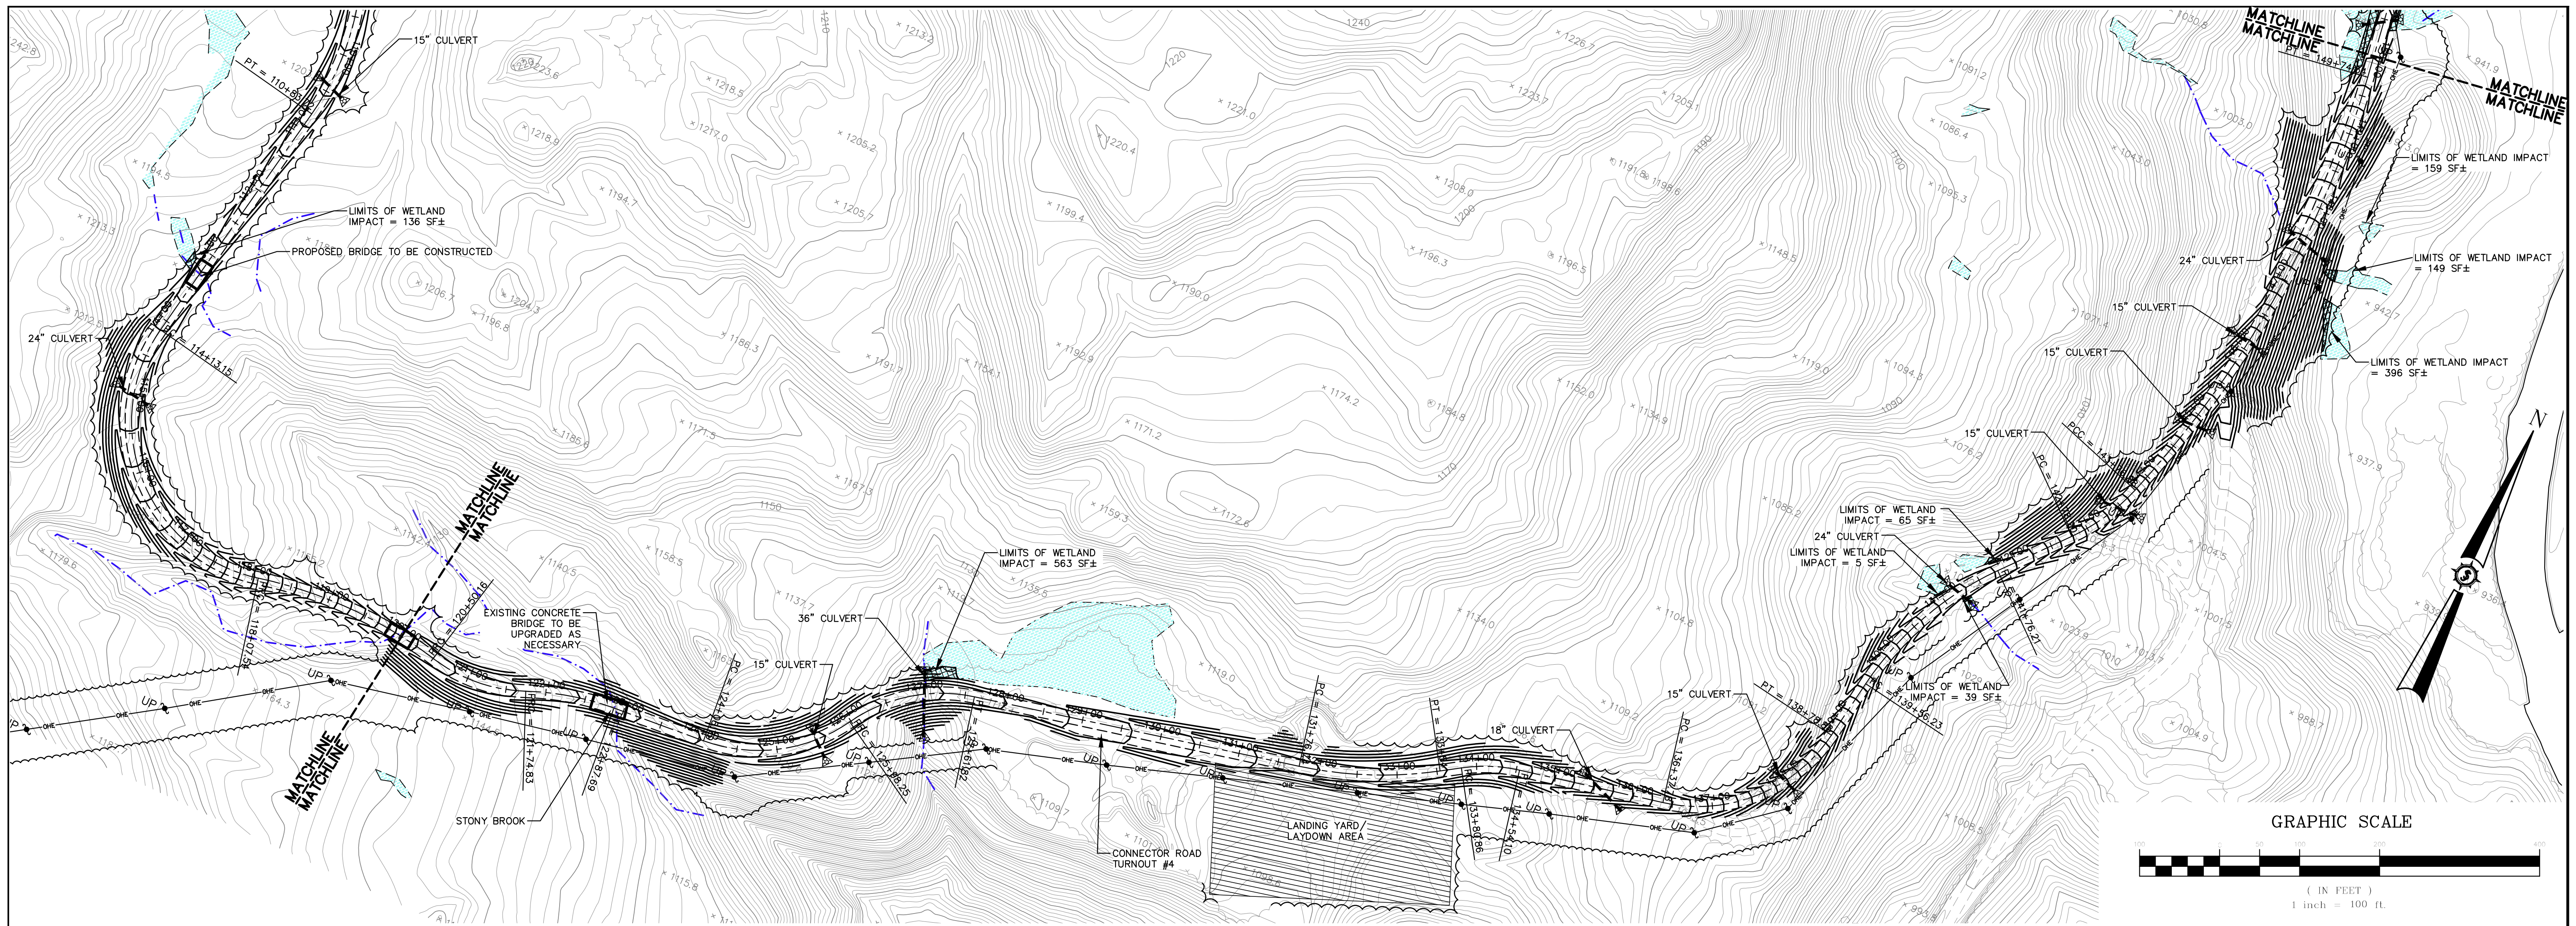

HIGHLAND WIND PROJECT
HIGHLAND WIND LLC

Project Location: HIGHLAND PLANTATION
 Drawing Description: CONNECTOR ROAD STA. 120+00 TO 150+00

Designed By: BOH
 Date: 12/20/2010
 Scale: H: 1"=100' V: 1"=50'

Drawn By: JCH
 Checked: JT

6060E



SEWALL
 JAMES W. SEWALL COMPANY / Since 1881
 SEWALL.COM 800.648.4202

Professional Engineer Seal: STATE OF MAINE, No. 10688, LICENSED PROFESSIONAL ENGINEER

PERMIT

Sheet No. **C-108**


NOT FOR CONSTRUCTION

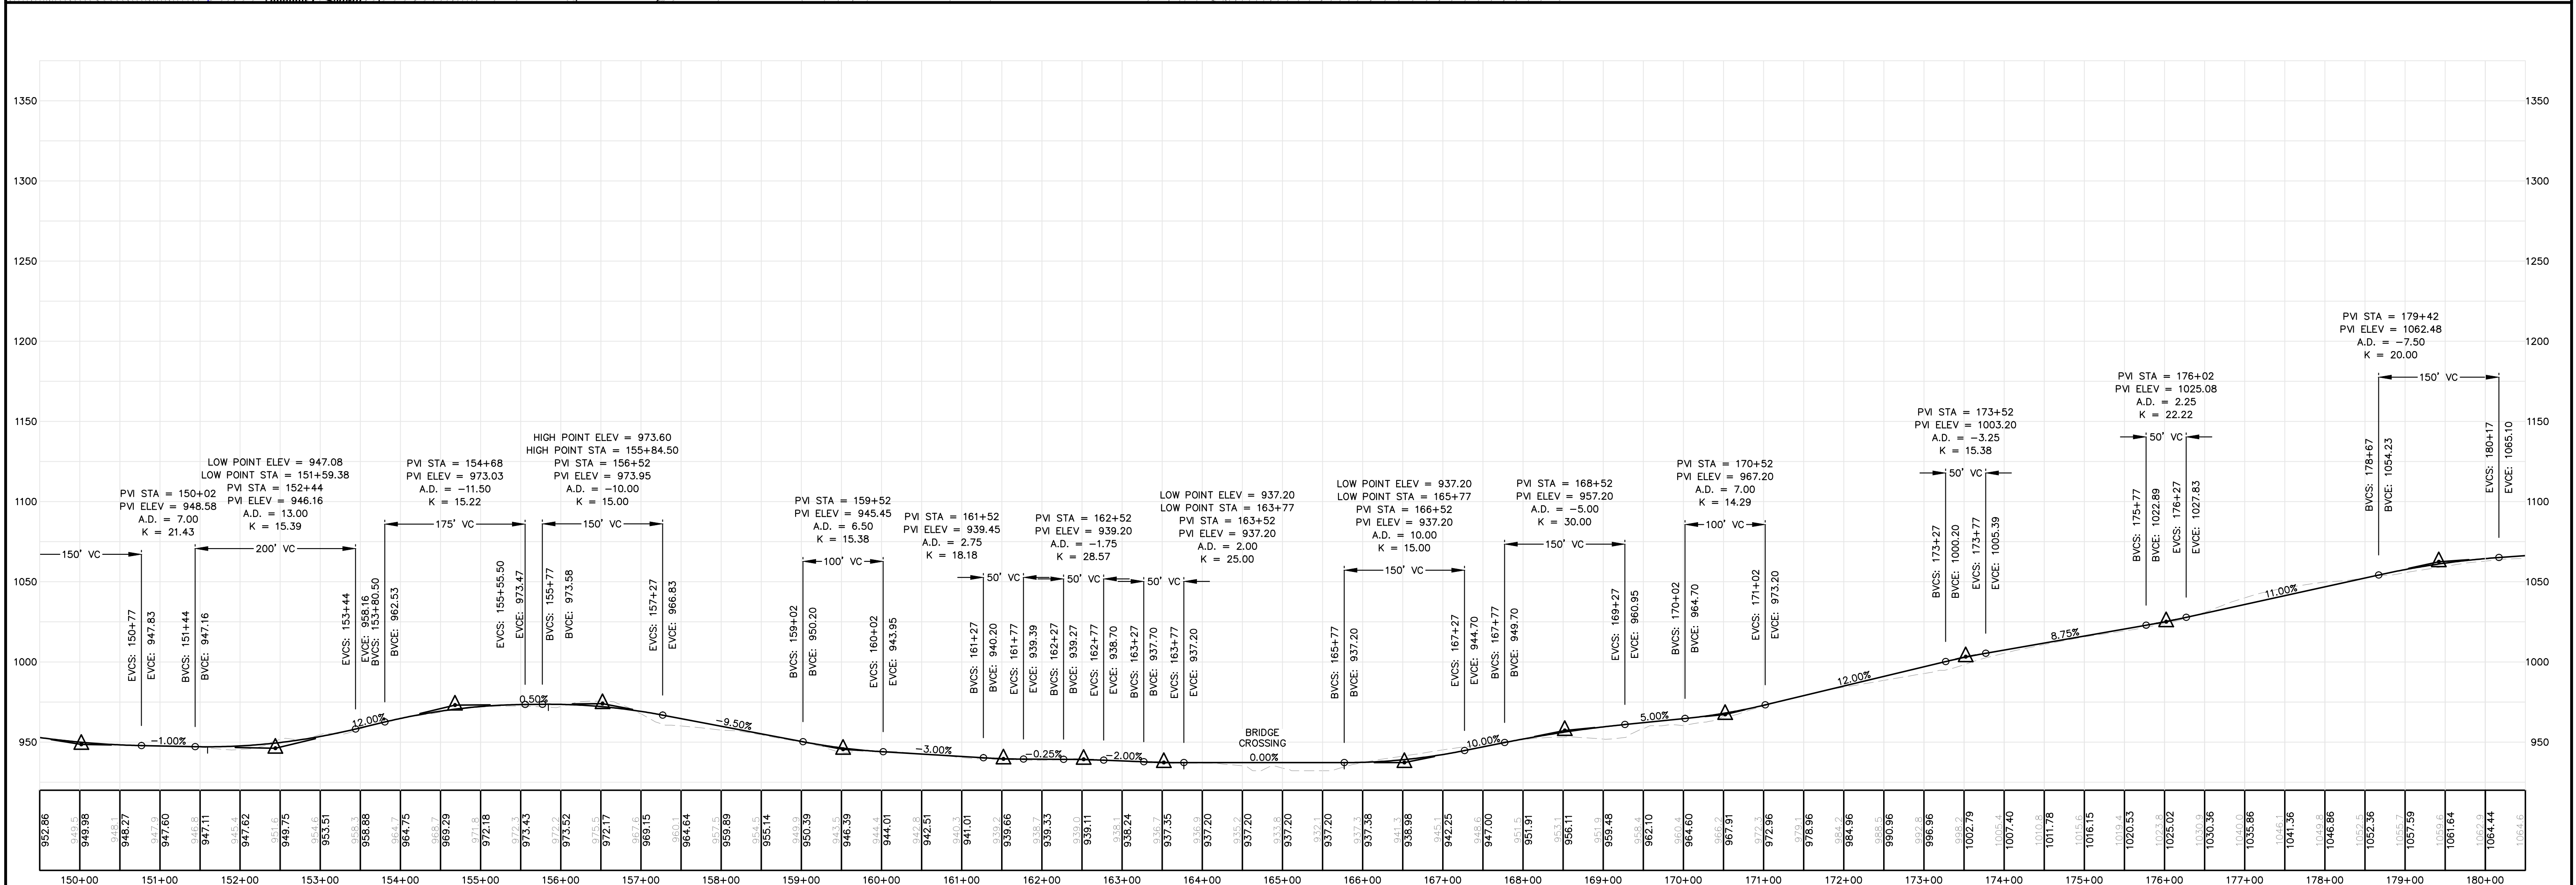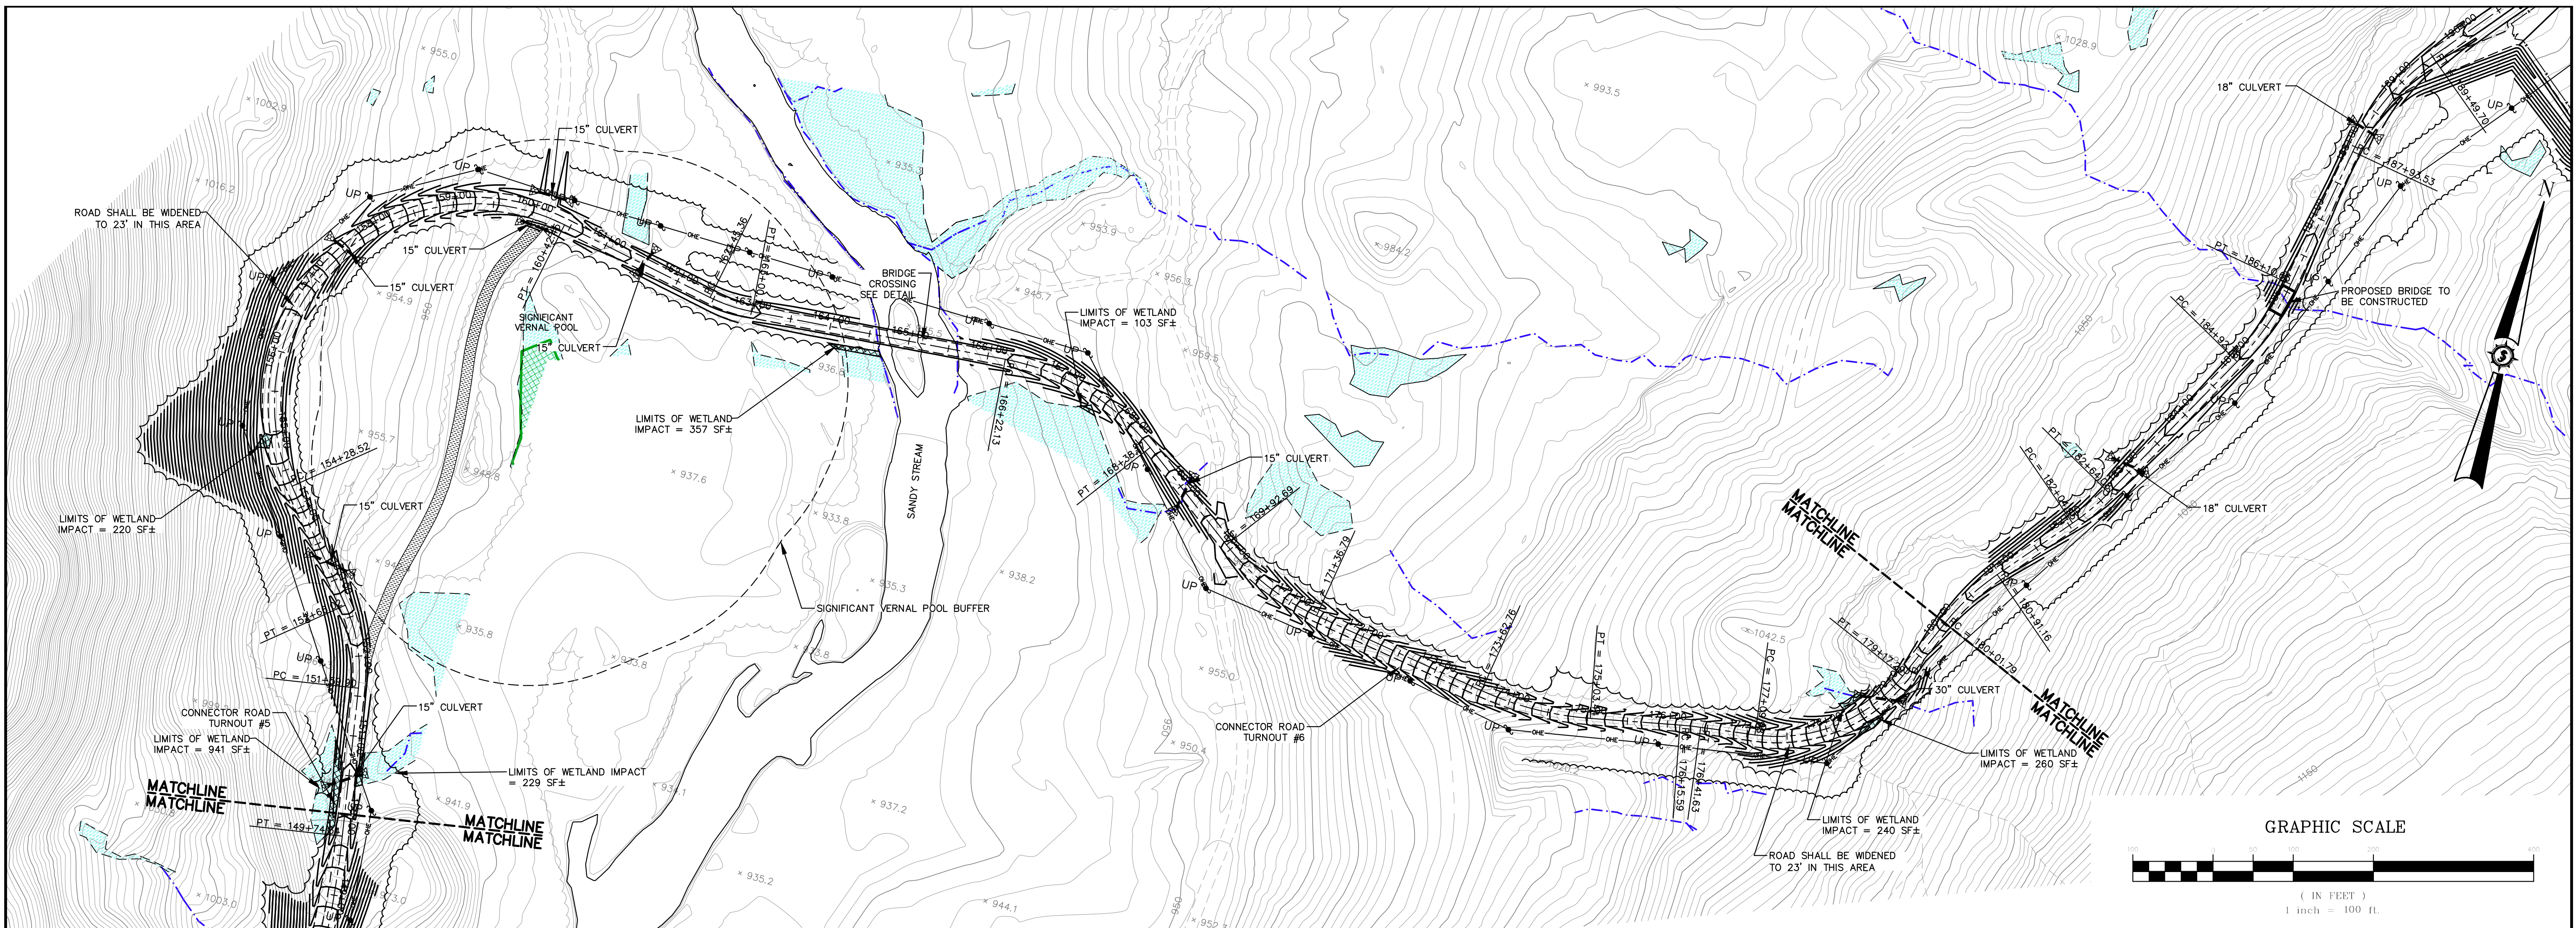

Rev.	Drawn By	Checked
1	JCH	JT

Drawn By	JCH
Date	12/20/2010
Scale	H: 1" = 100 V: 1" = 50'

HIGHLAND WIND PROJECT
HIGHLAND WIND LLC
 Project Location: HIGHLAND PLANTATION
 Drawing Description: CONNECTOR ROAD STA. 150+00 TO 180+00



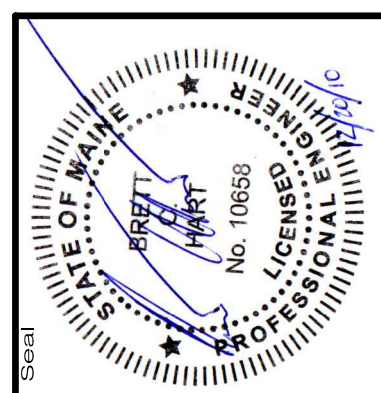


60606E
SEWALL
 an integrated team of geospatial, engineering, surveying and NATURAL RESOURCE consultants
 JAMES W. SEWALL COMPANY / Since 1880
 SEWALL.COM 800.648.4202

Phase: PERMIT
 Sheet No. C-109

C-109

NOT FOR CONSTRUCTION

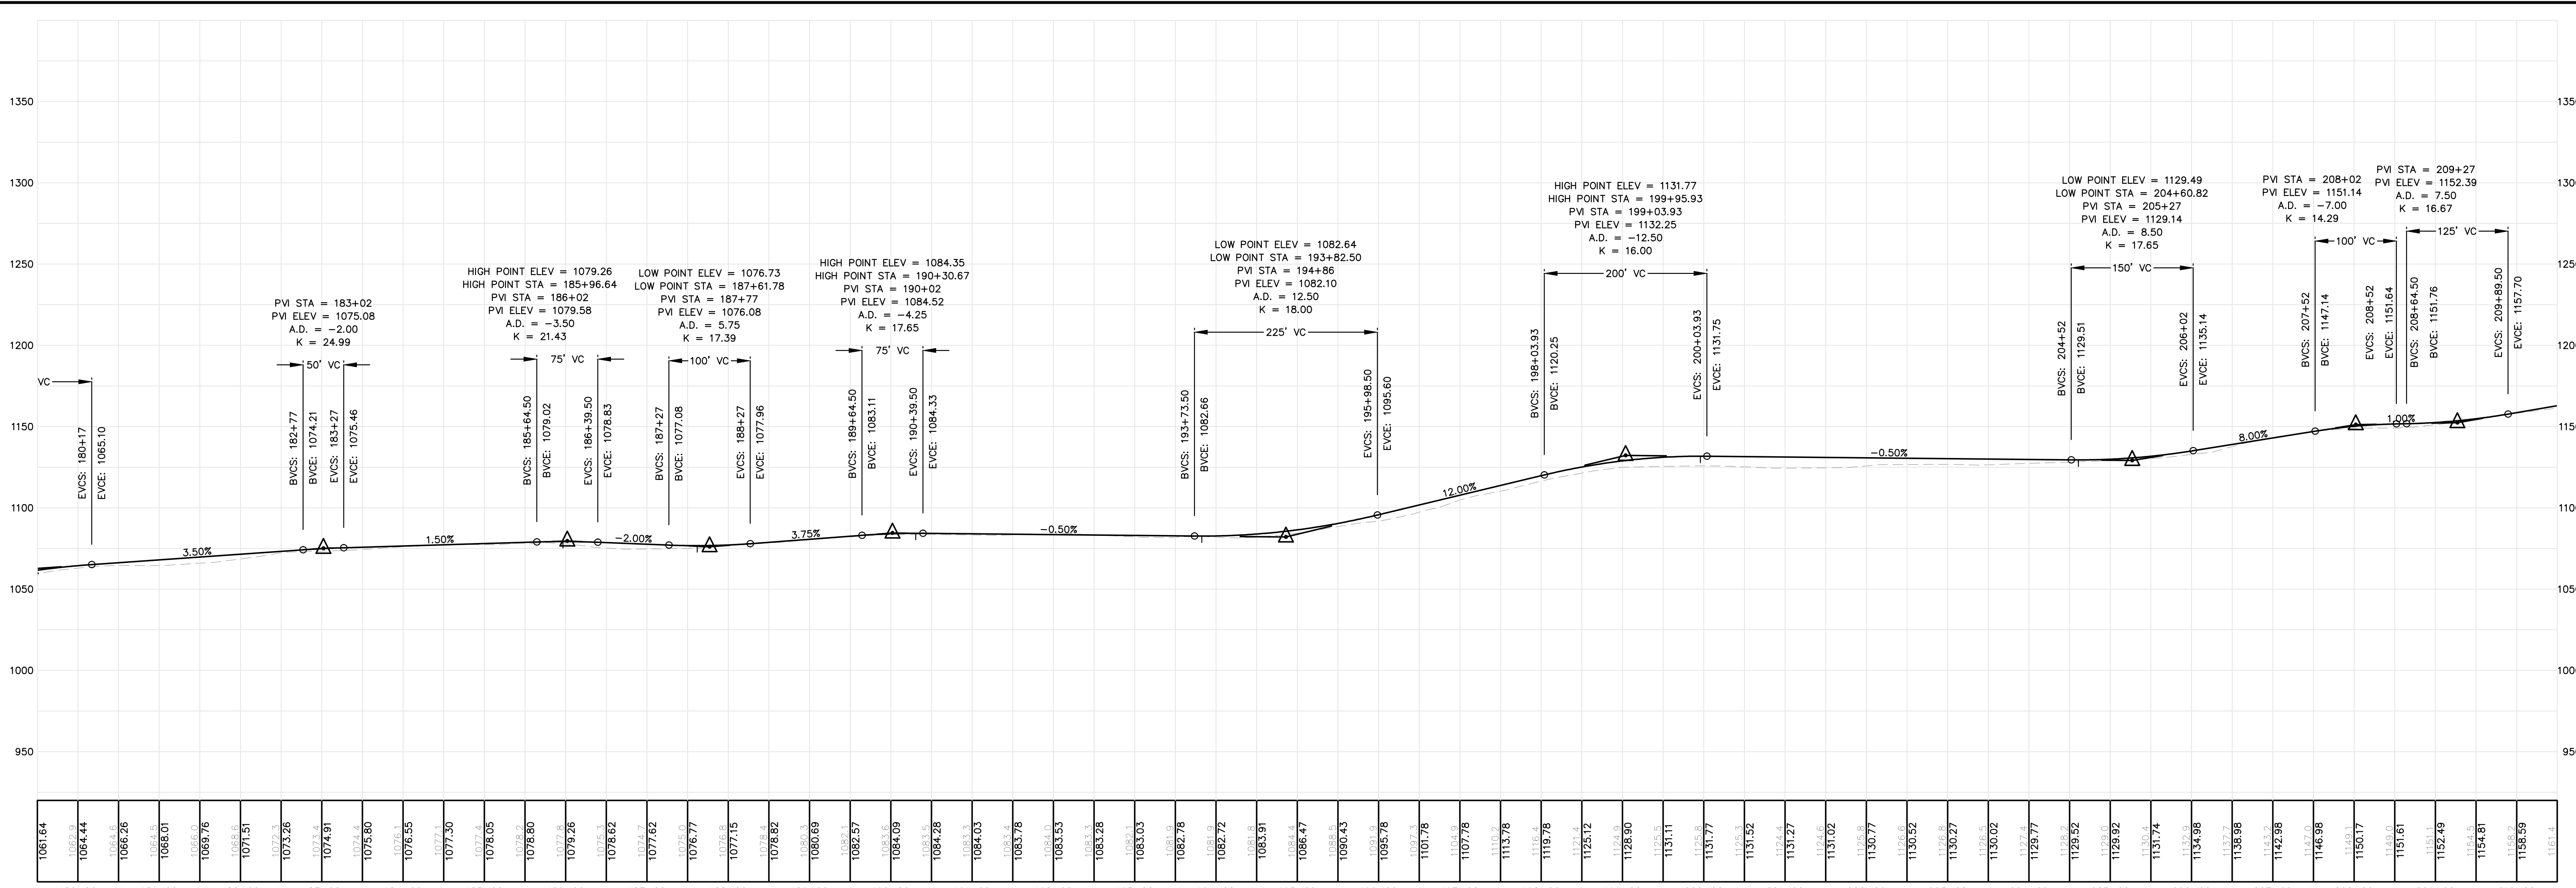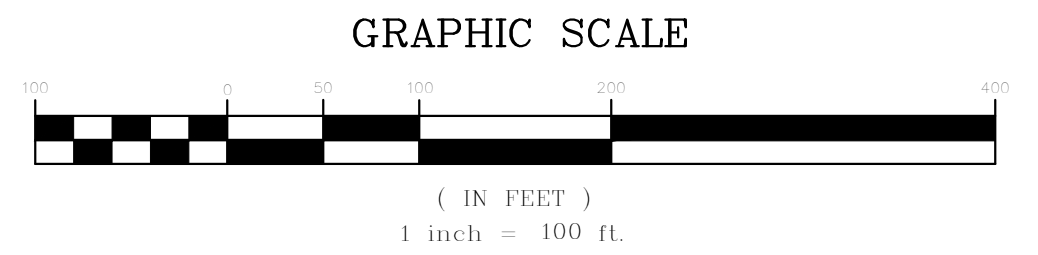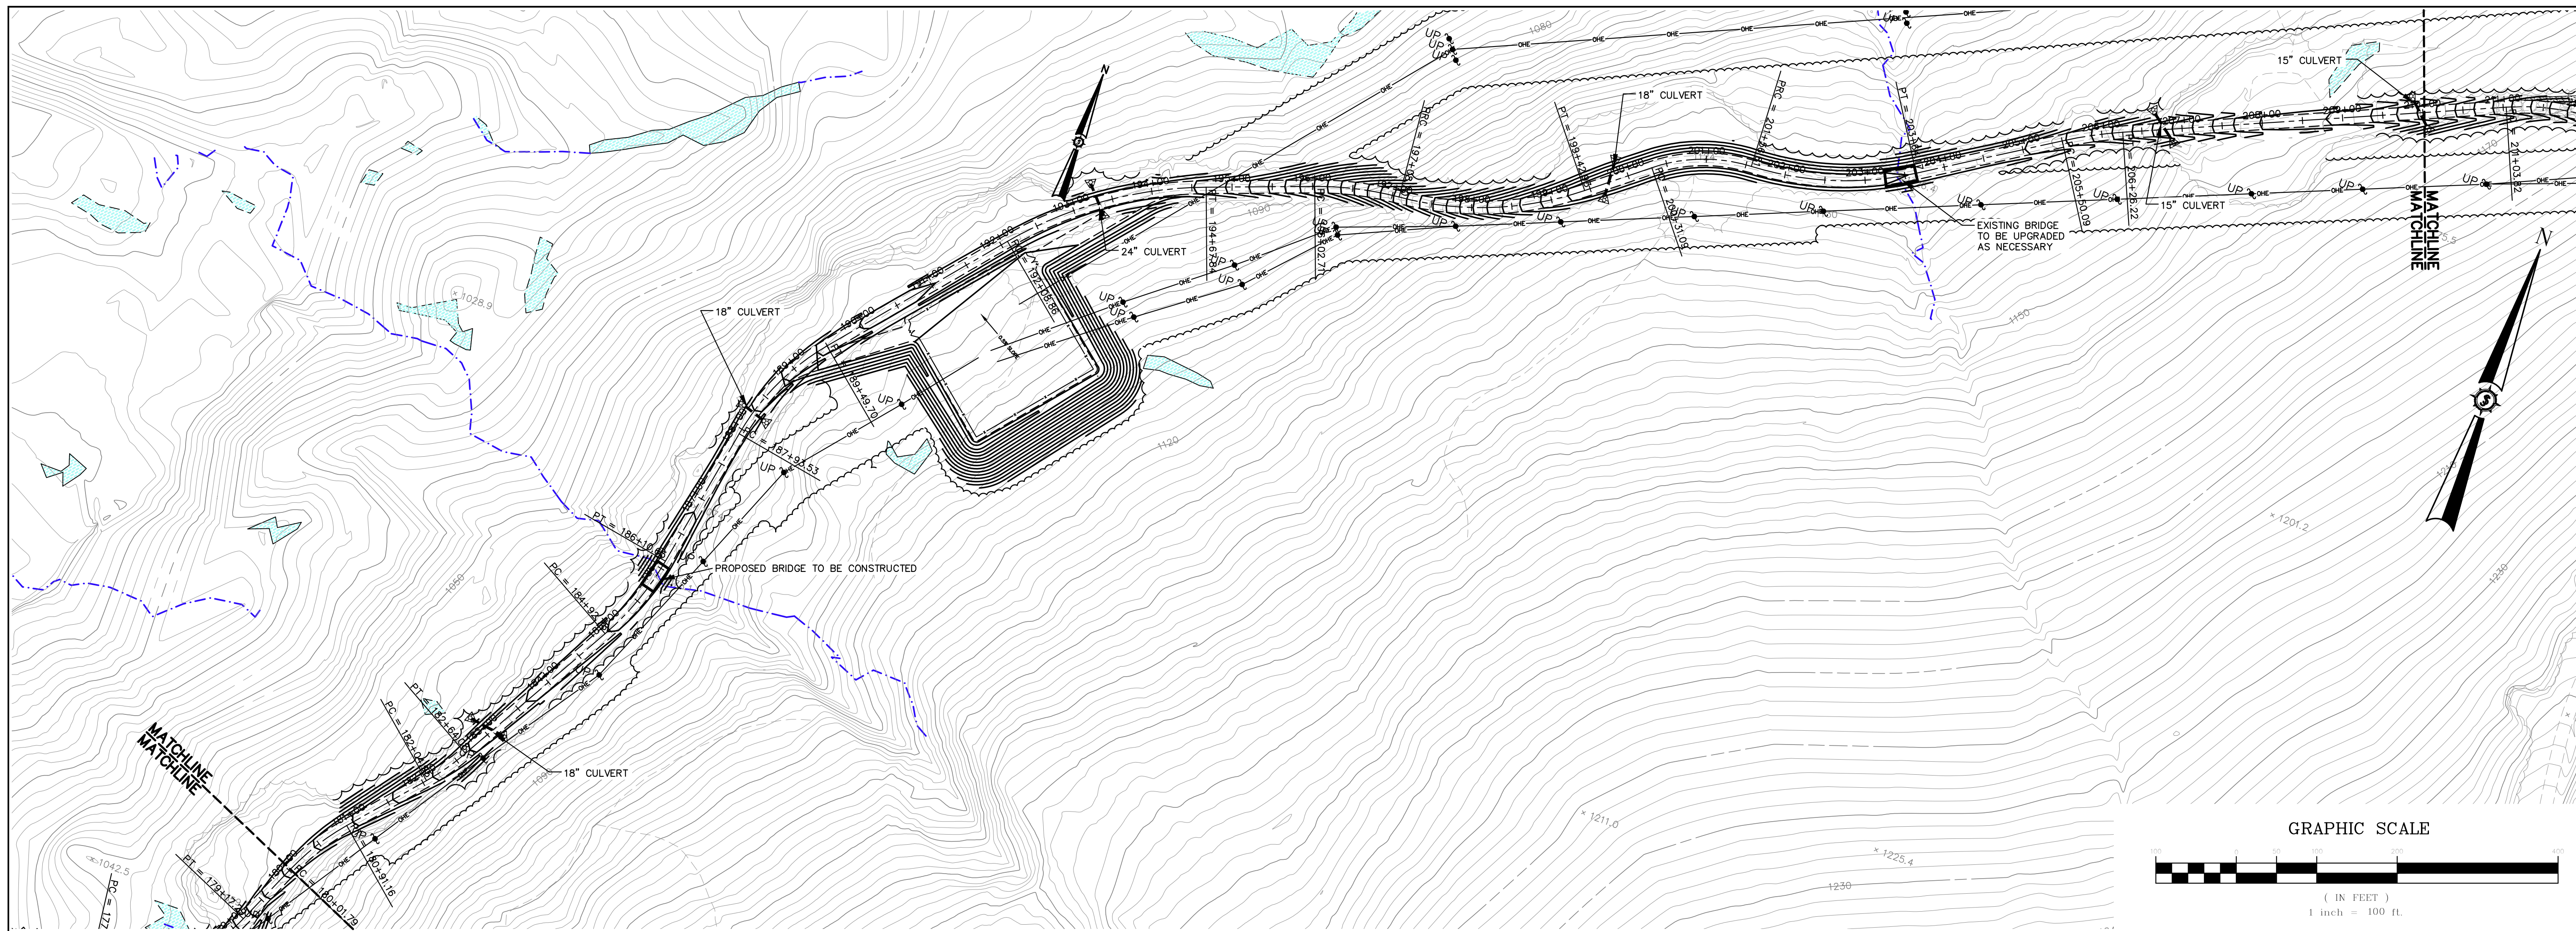

Project No.	60606
Sheet No.	C-110
Drawn By	JCH
Checked	JT
Designated By	BOH
Date	12/20/2010
Scale	H: 1"=100' V: 1"=50'
Project Location	HIGHLAND PLANTATION
Project Name	HIGHLAND WIND PROJECT
Client	HIGHLAND WIND LLC
Contract No.	1068
Revision	1
Drawn	JCH
Checked	JT
Approved	BOH
Project Description	CONNECTOR ROAD STA. 180+00 TO 210+00

HIGHLAND WIND PROJECT
HIGHLAND WIND LLC

Project Location
 HIGHLAND PLANTATION

Contract No.
 1068


Revision
 1

Drawn
 JCH

Checked
 JT

Approved
 BOH

Project Description
 CONNECTOR ROAD STA. 180+00 TO 210+00

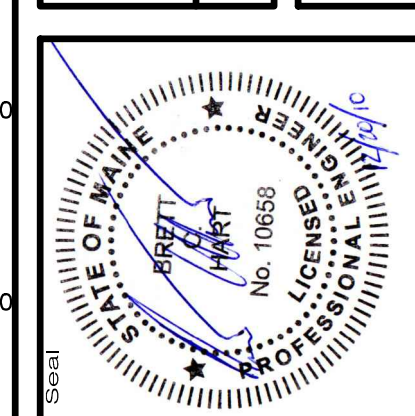

60606

SEWALL




JAMES W. SEWALL COMPANY / Since 1881
 800 648 4202
 SEWALL.COM

an integrated team of
 geospatial, engineering,
 surveying and NURSAL
 RESOURCE CONSULTANTS

PERMIT

Sheet No.
C-110

NOT FOR CONSTRUCTION

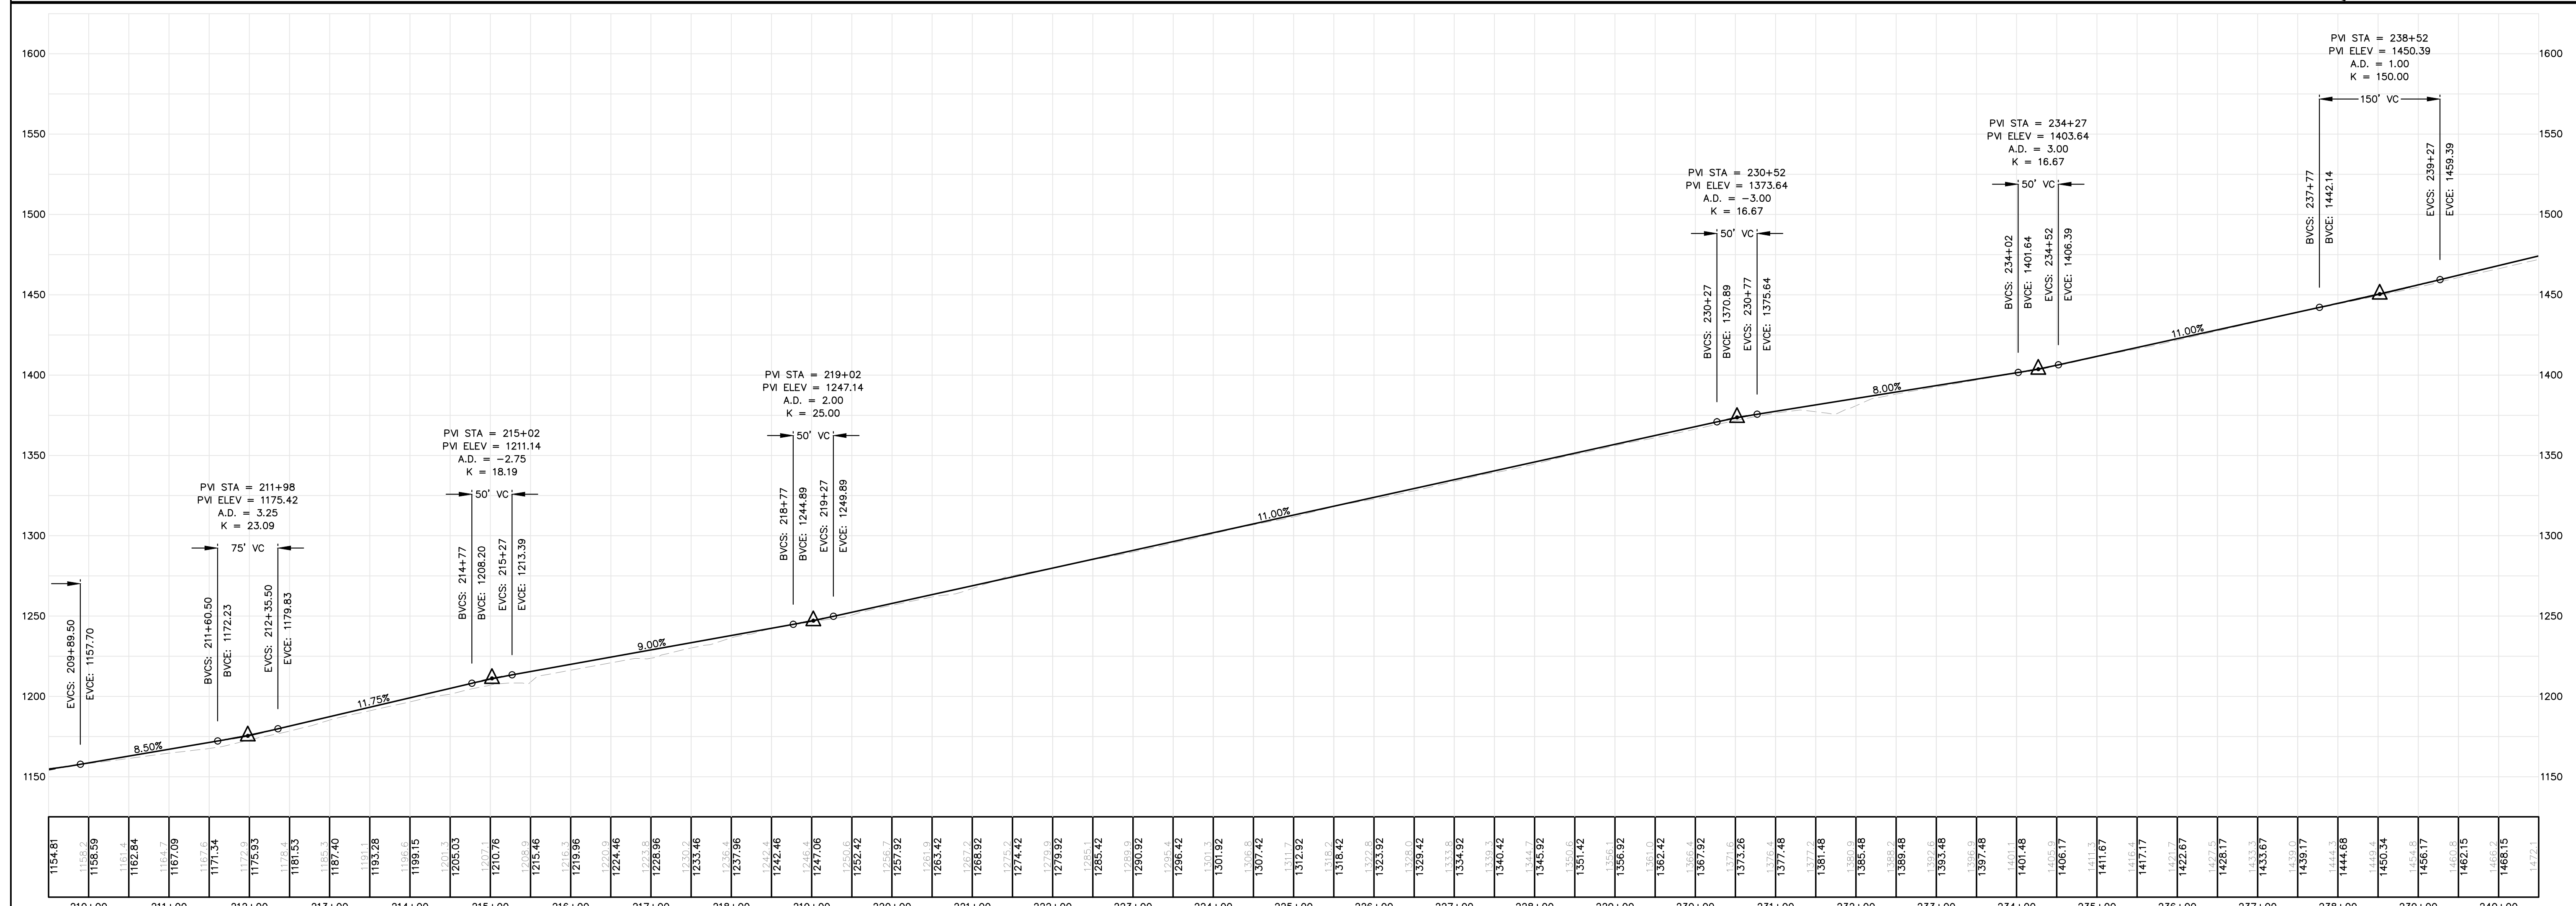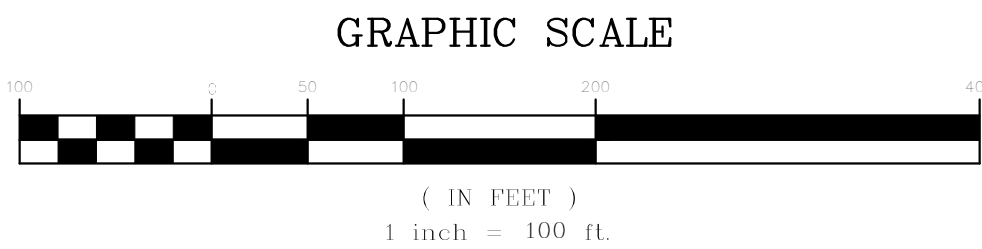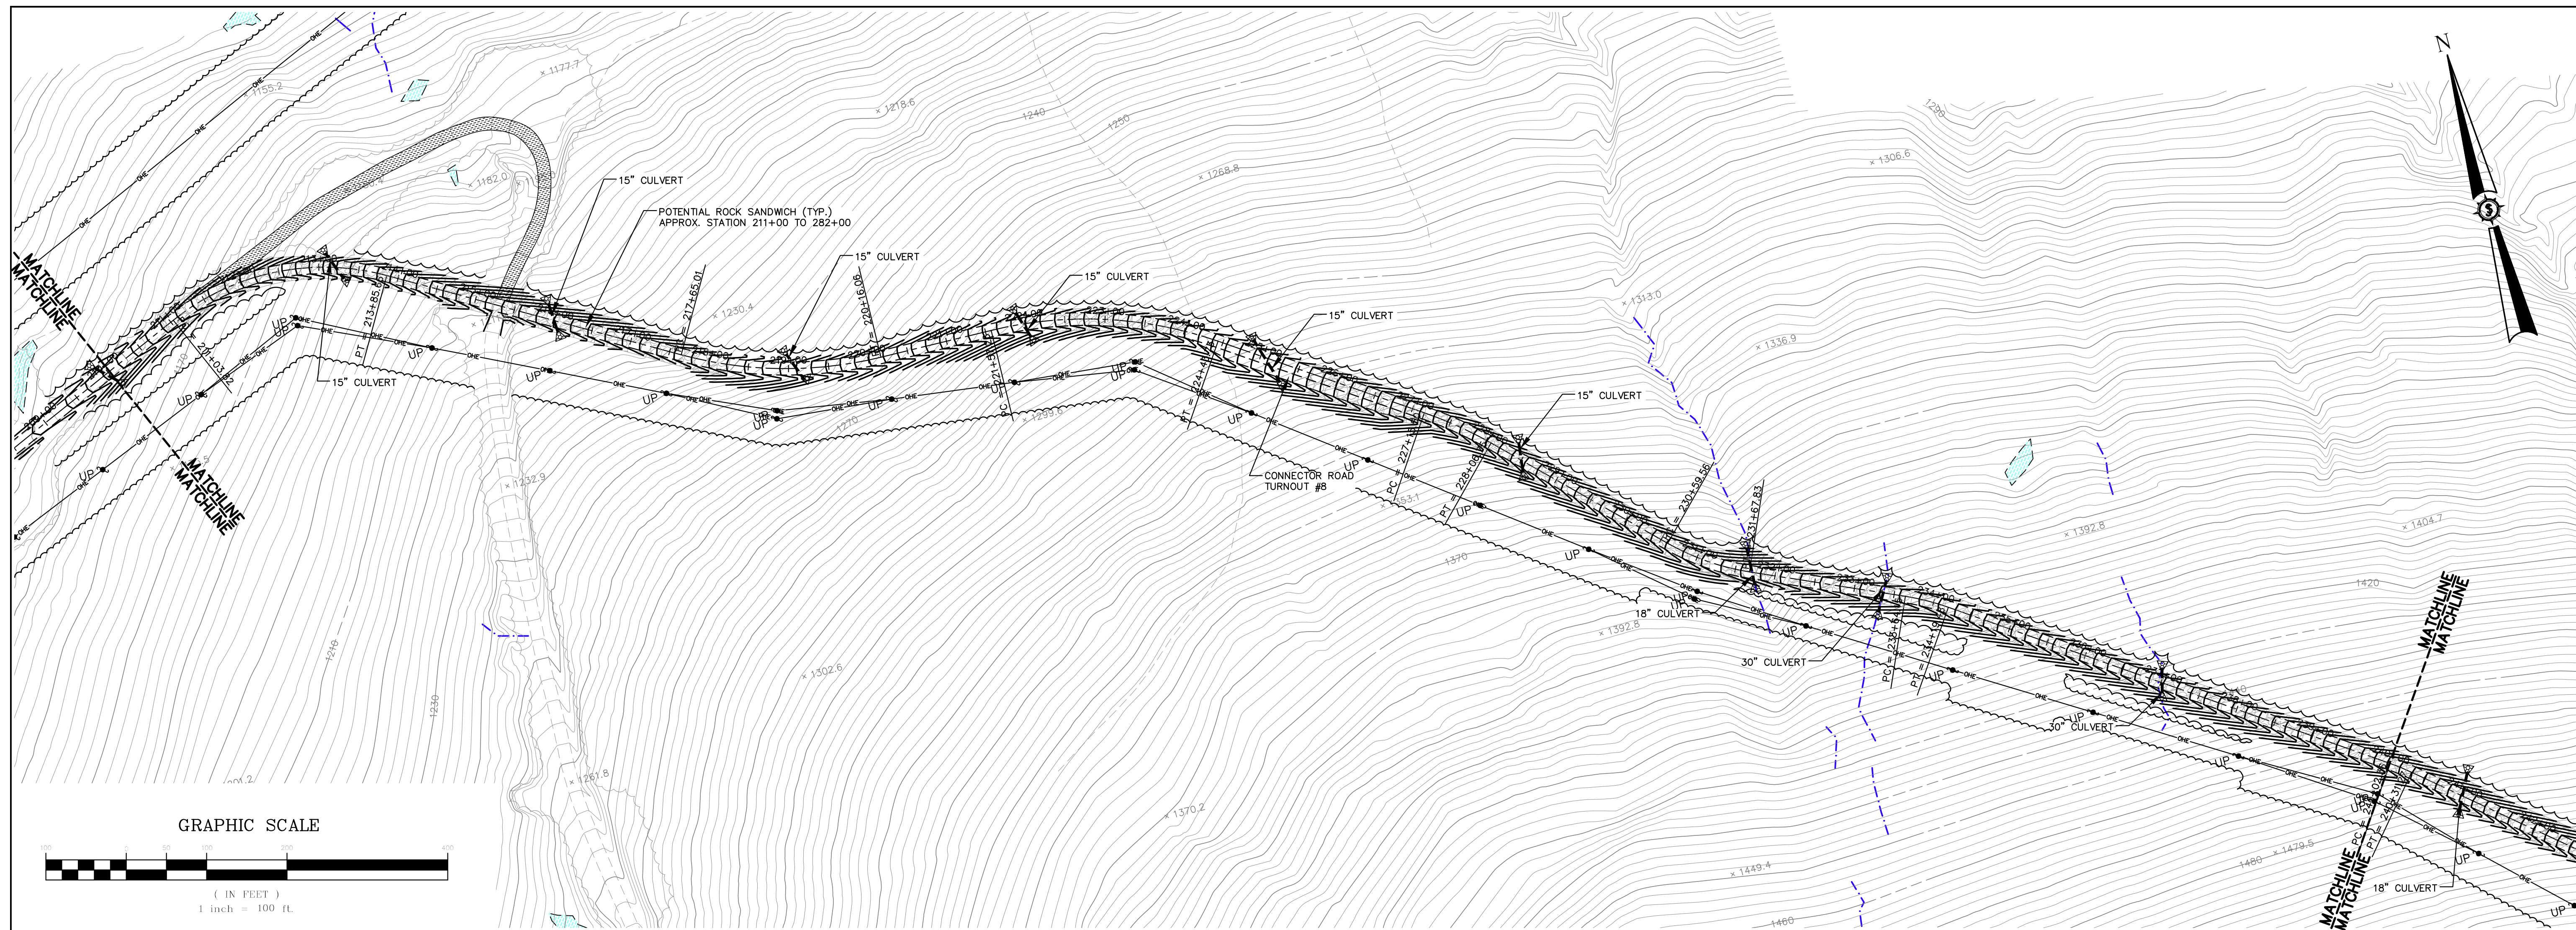


Drawn By	JCH
Designated By	BOH
Date	12/20/2010
Scale	H: 1"=100' V: 1"=50'
Checked	JT
Approved	BOH

HIGHLAND WIND PROJECT
HIGHLAND WIND LLC

Project Location
HIGHLAND PLANTATION

Drawing Description
CONNECTOR ROAD STA. 210+00 TO 240+00


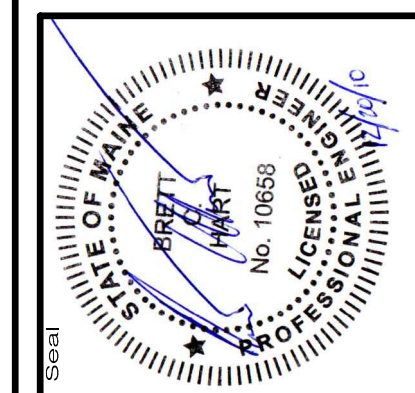


60606E

on integrated team of
 geospatial, engineering,
 surveying and NUTRAL
 RESOURCE consultants

SEWALL
 JAMES W. SEWALL COMPANY / Since 1881
 SEWALL.COM
 800 648 4202


NOT FOR CONSTRUCTION

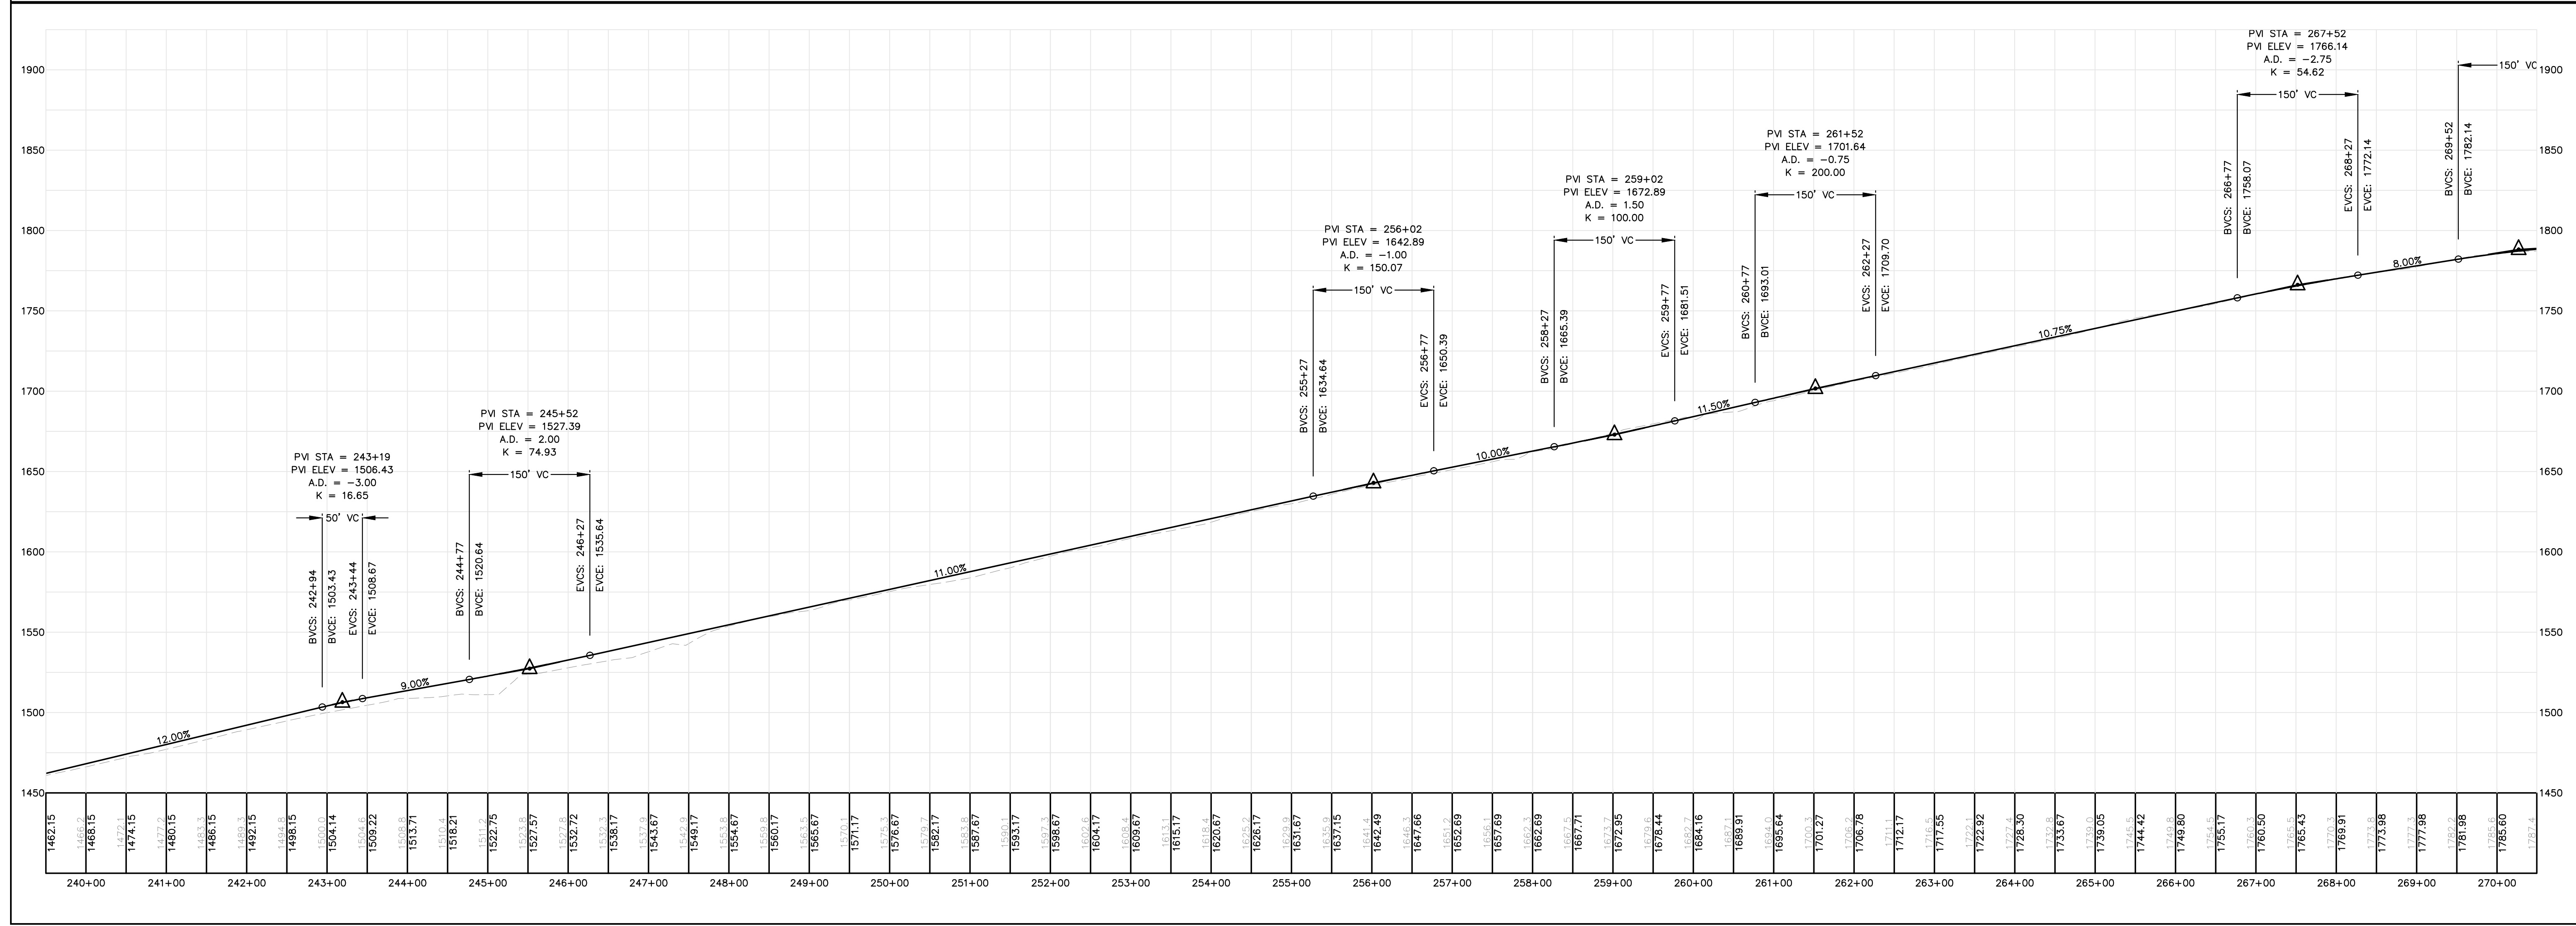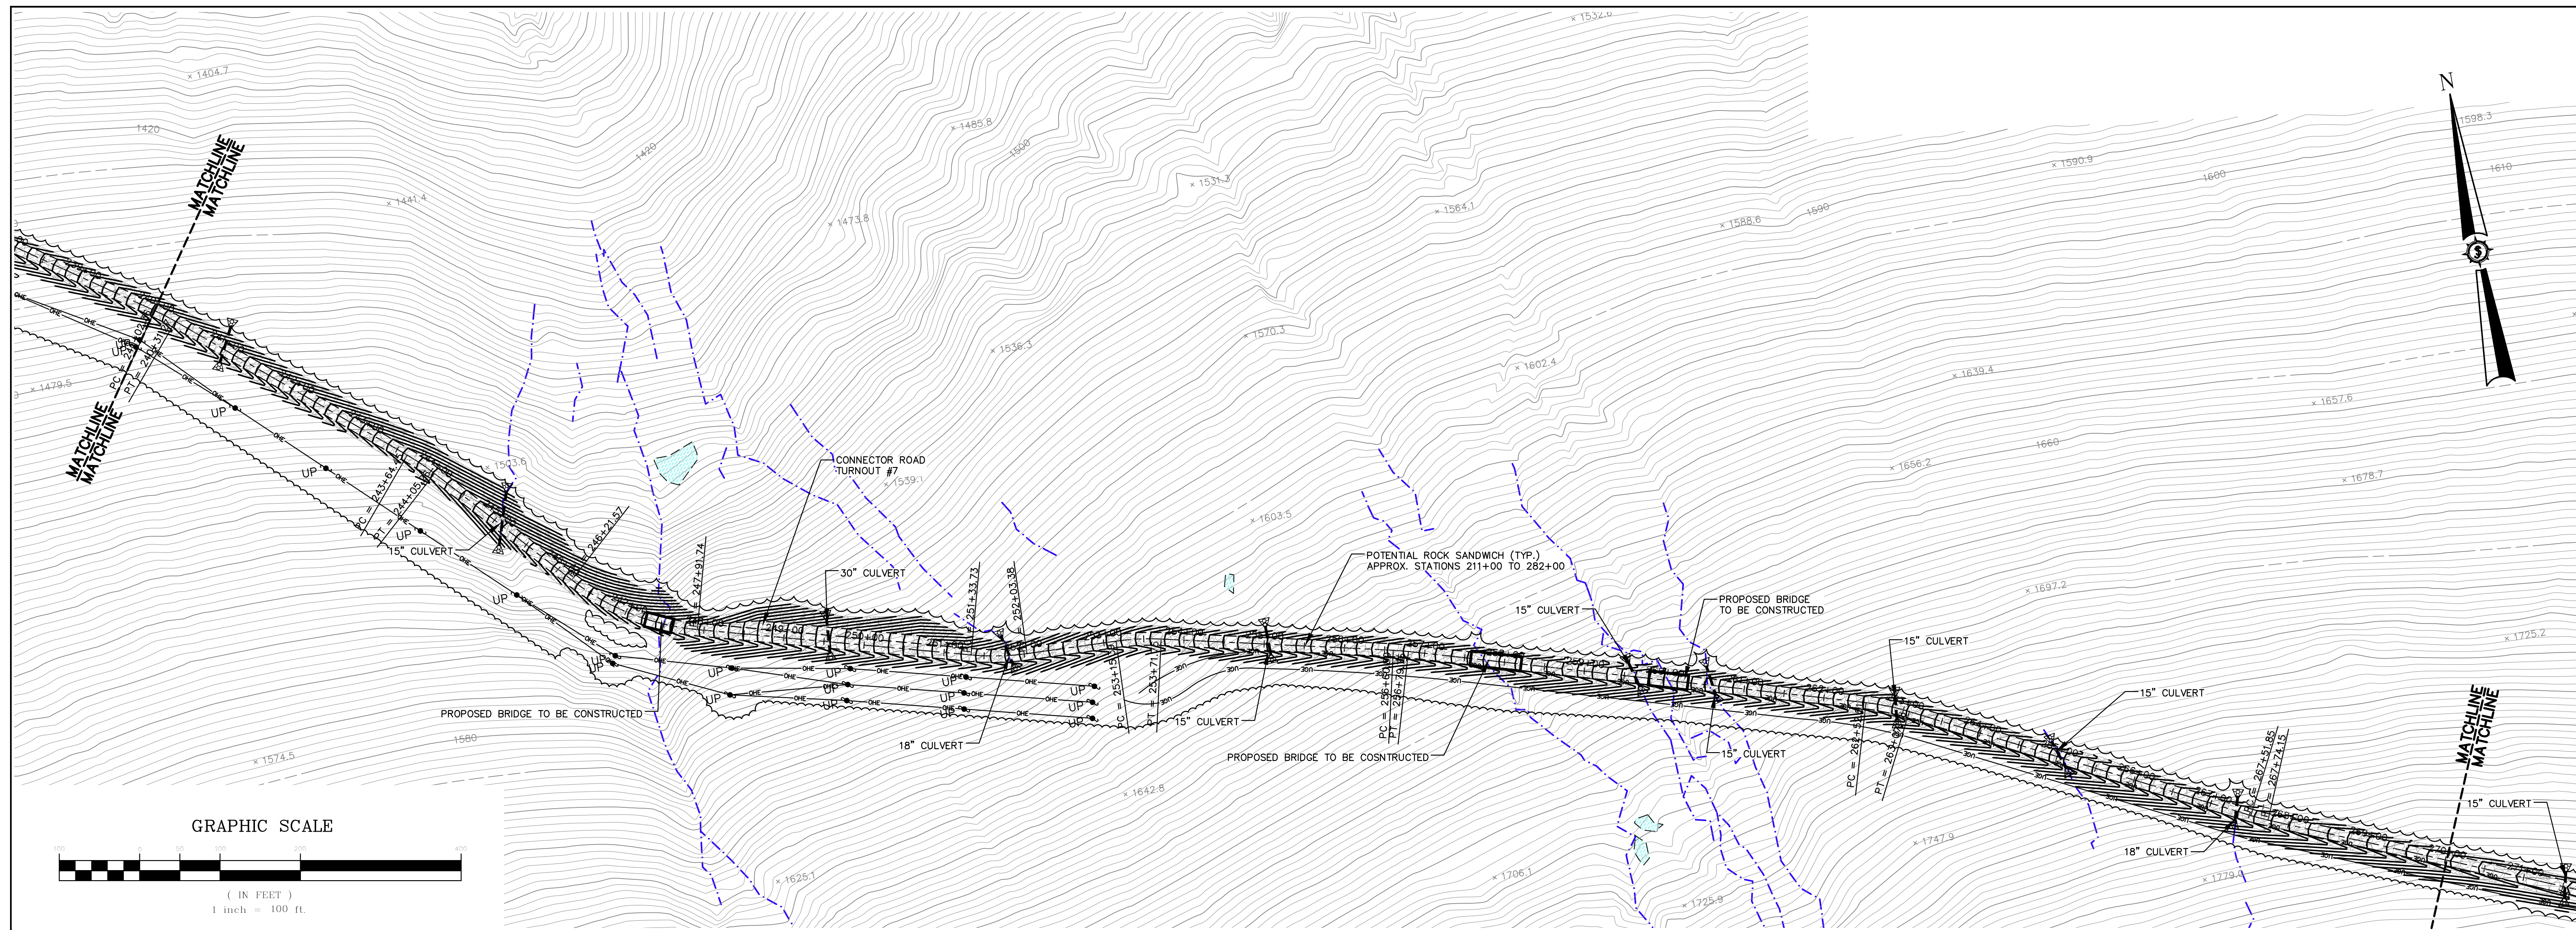

Date	
Drawn By	JCH
Checked	JT

Designed By	BOH
Date	12/20/2010
Scale	H: 1"=100' V: 1"=50'
Approved	BOH
Checked	JT

HIGHLAND WIND PROJECT
HIGHLAND WIND LLC
 Project Location
 HIGHLAND PLANTATION
 CONNECTOR ROAD
 STA. 240+00 TO 270+00



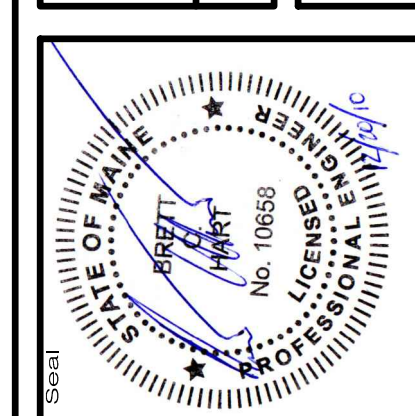


60606E
SEWALL
 on integrated team of
 geospatial, engineering,
 surveying and natural
 resource consultants
 JAMES W. SEWALL COMPANY / Since 1881
 SEWALL.COM
 800.648.4262

PERMIT

Sheet No.
C-112

NOT FOR CONSTRUCTION

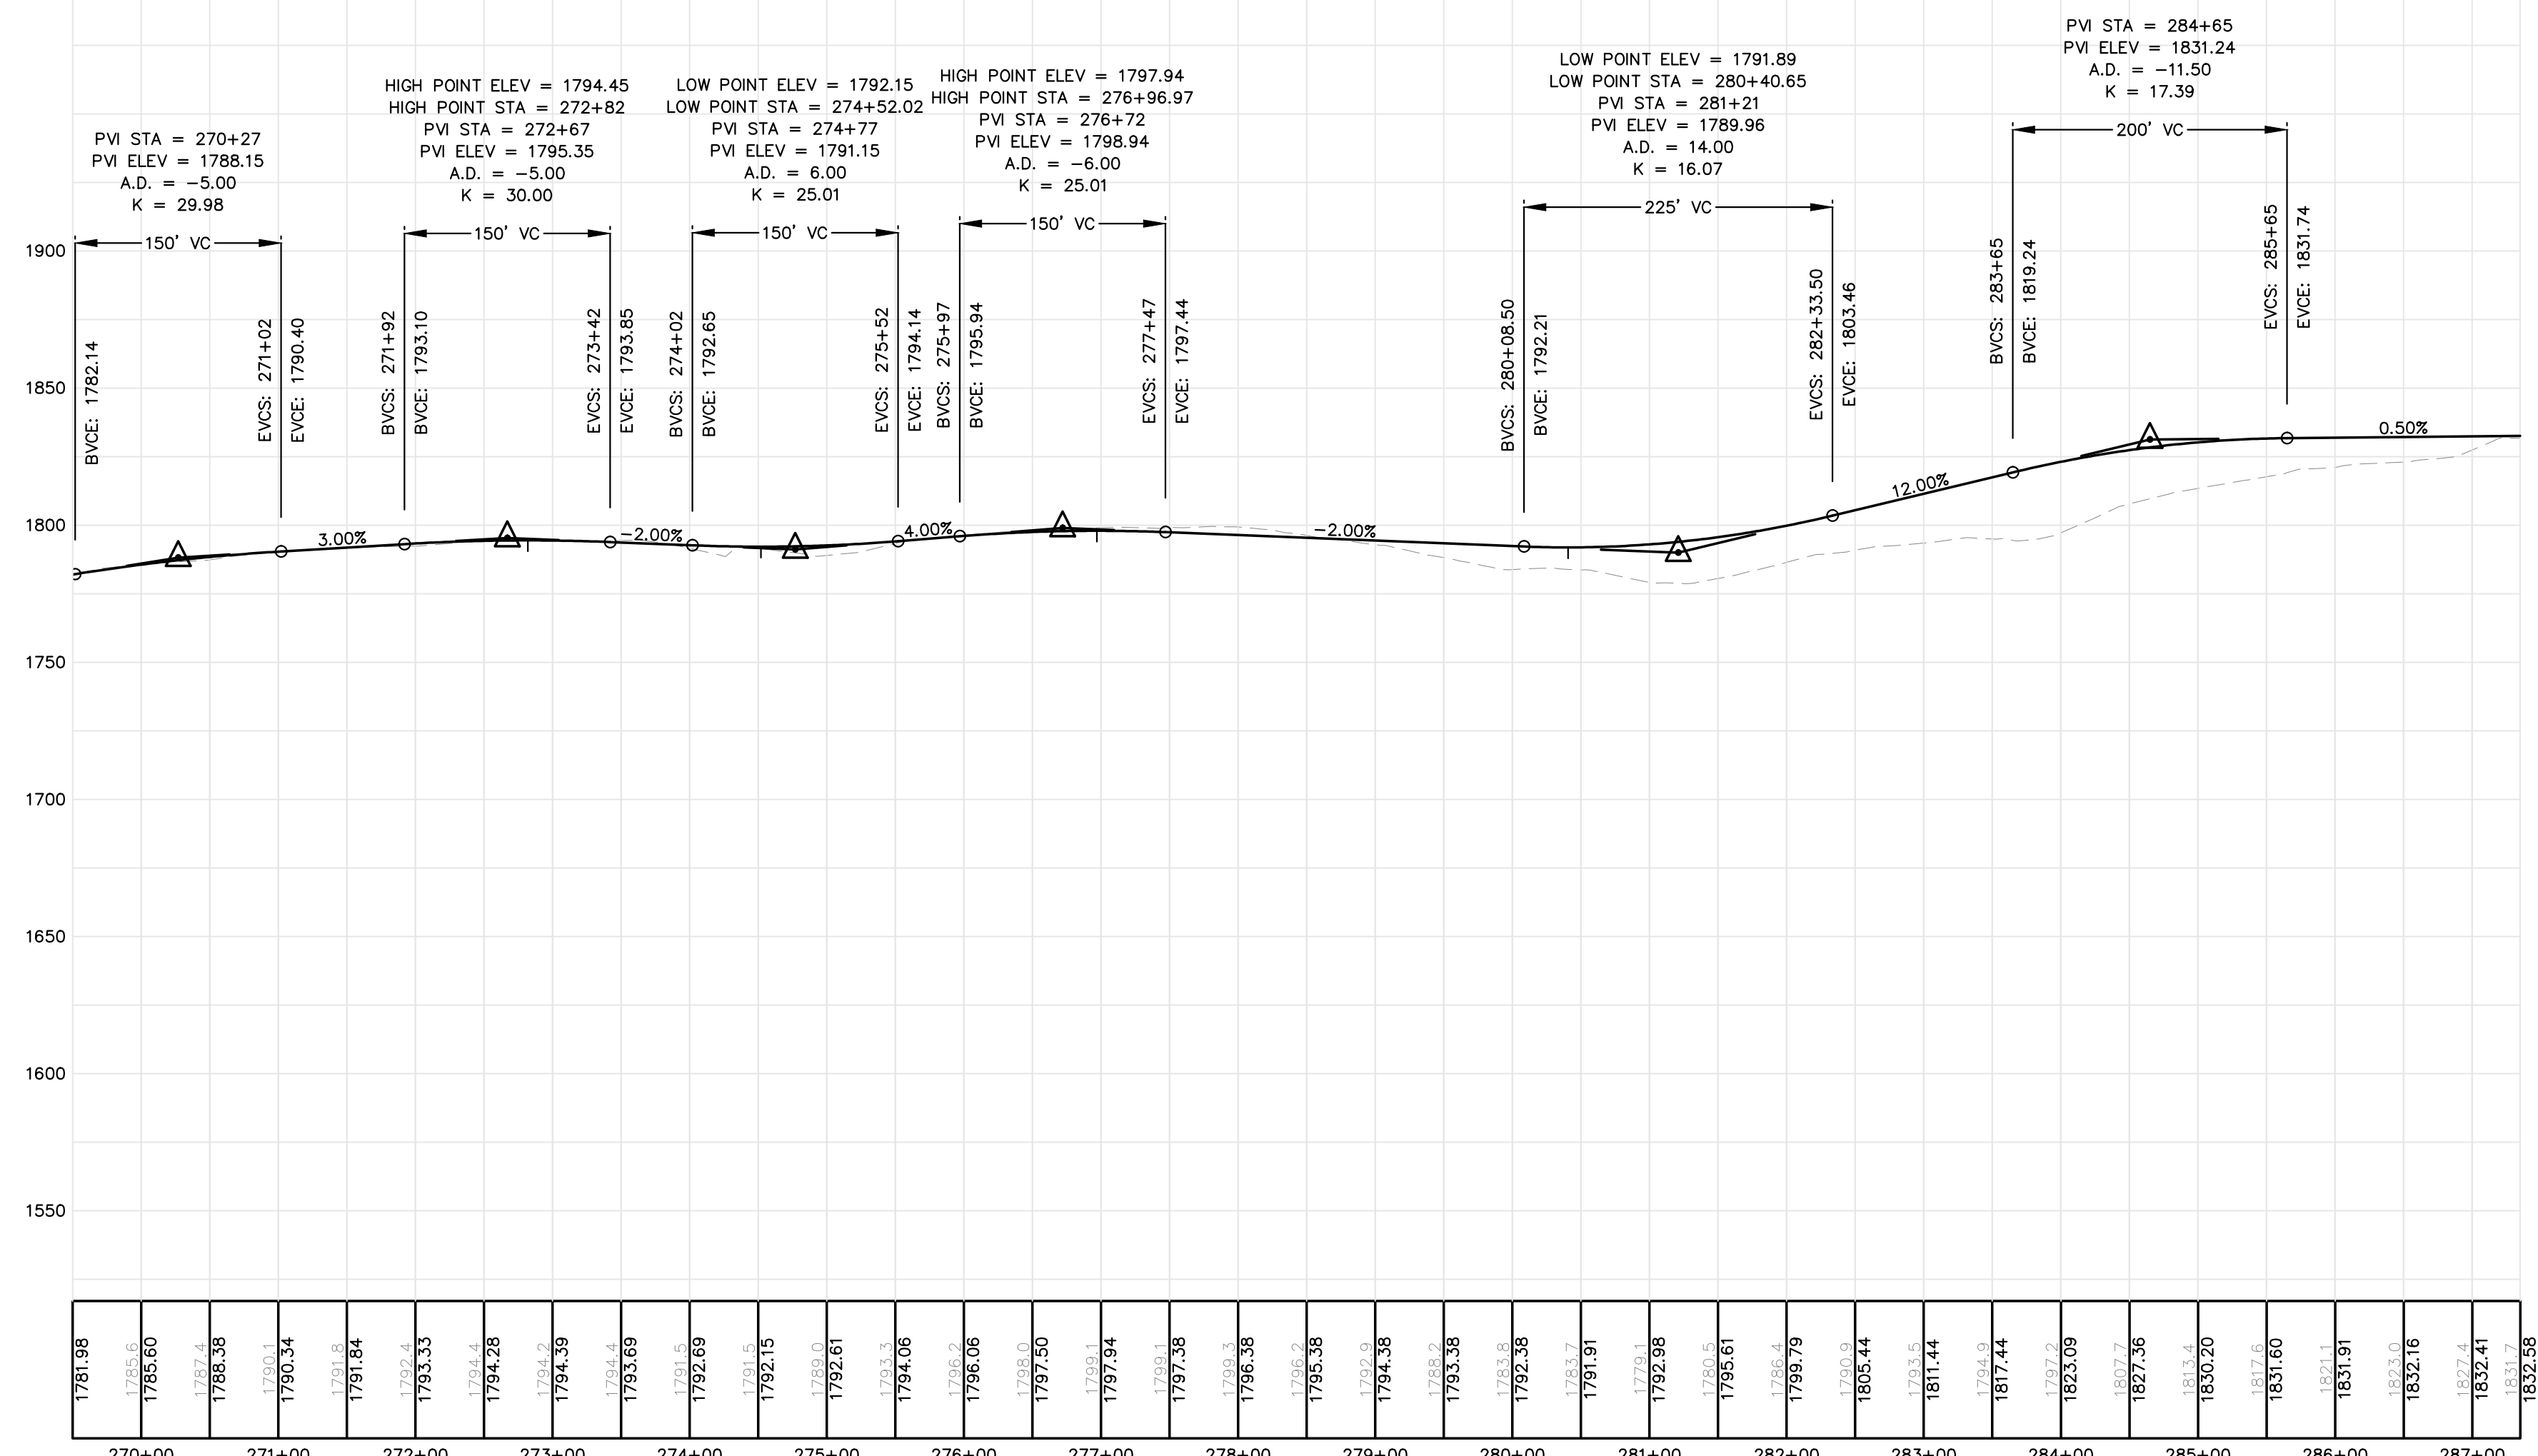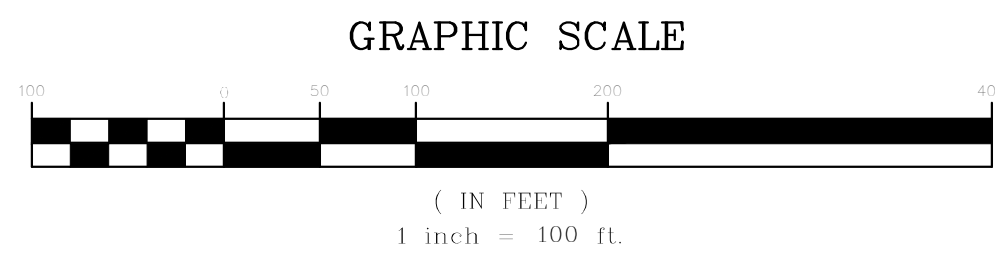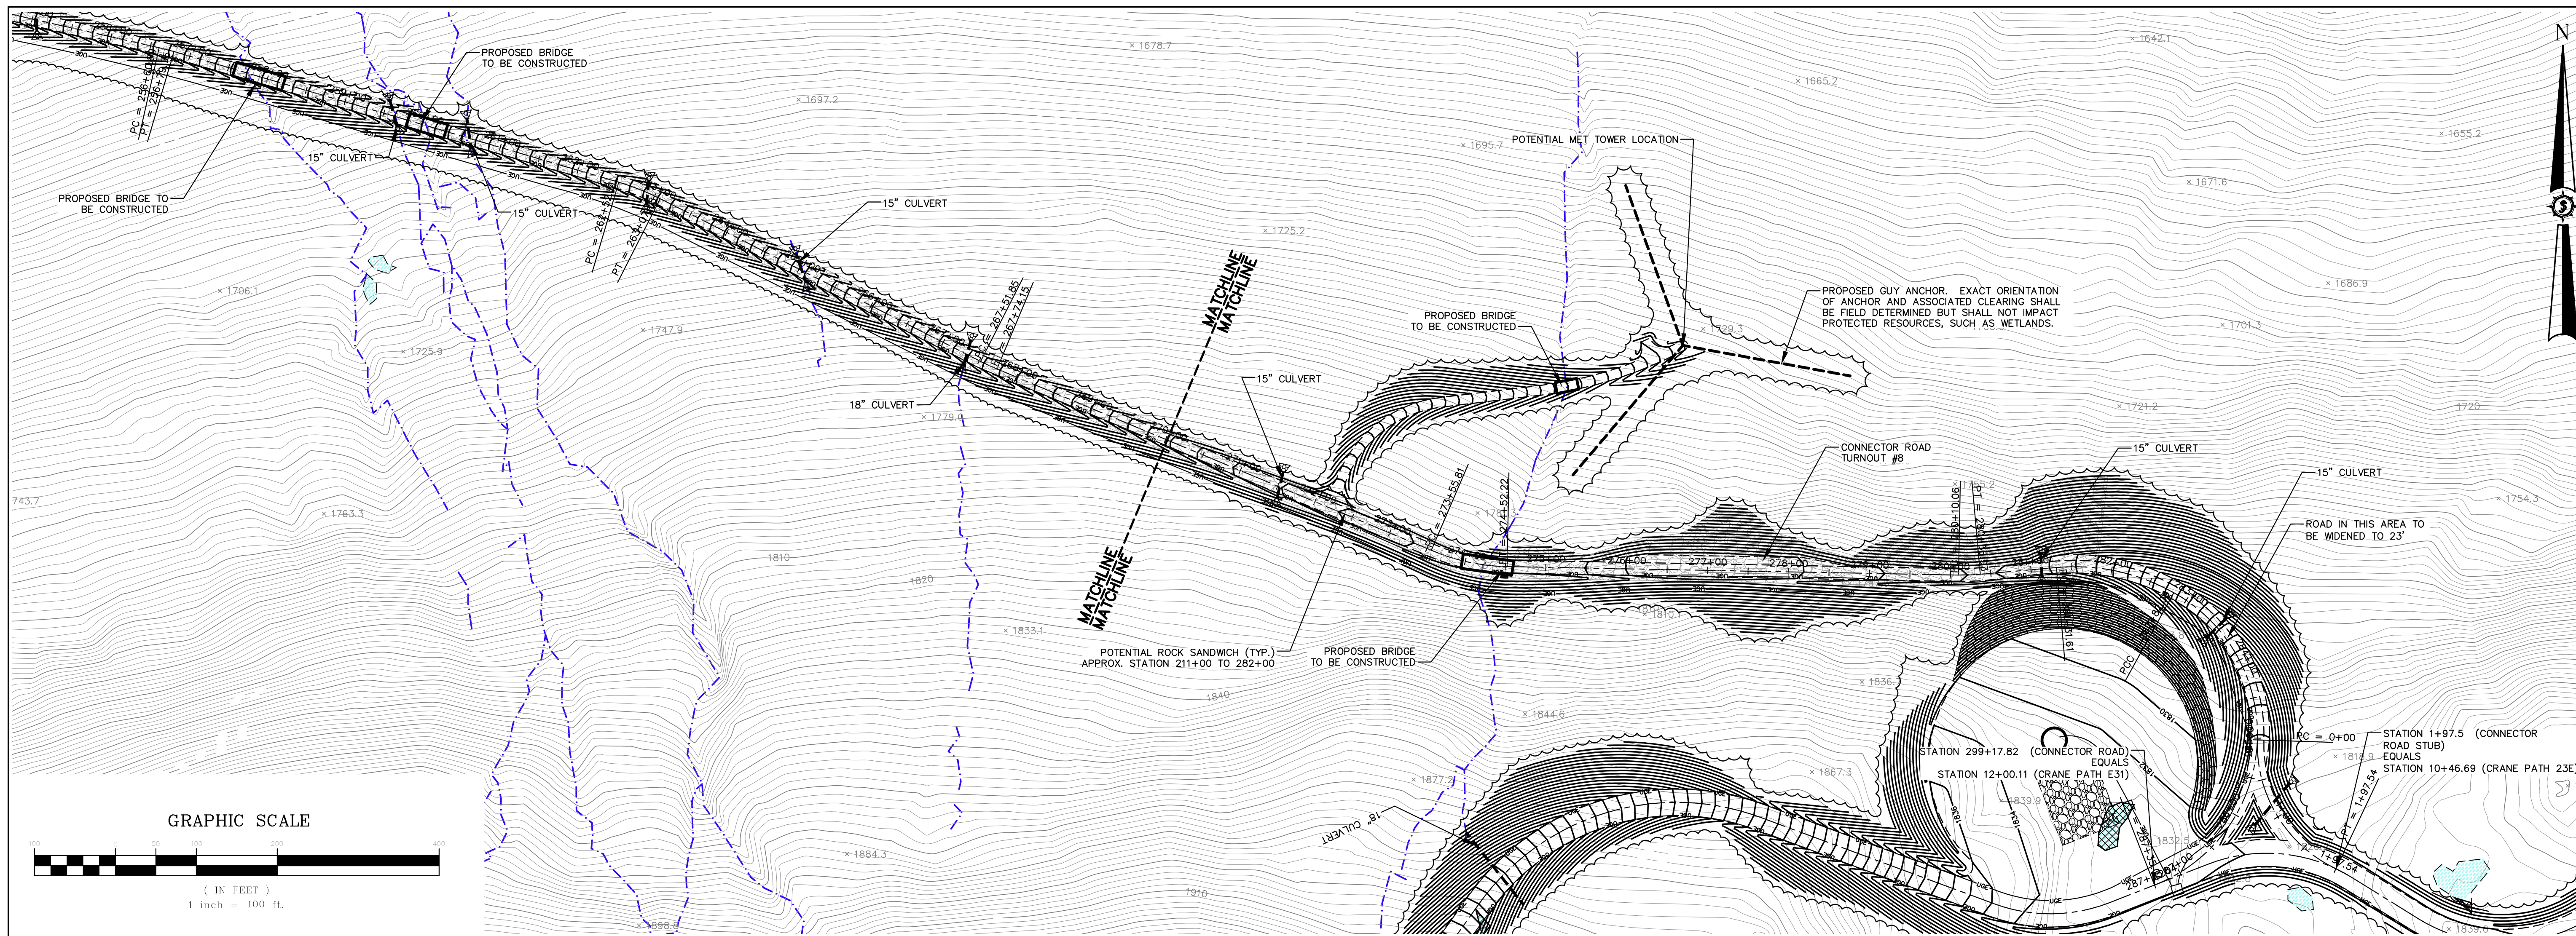


Date	
Drawn By	JCH
Designated By	BOH
Date	12/20/2010
Scale	H: 1"=100' V: 1"=50'
Checked	JT
Approved	BOH

HIGHLAND WIND PROJECT
HIGHLAND WIND LLC

Project Location
 HIGHLAND PLANTATION

Drawing Description
CONNECTOR ROAD
STA. 270+00 TO 287+33.04

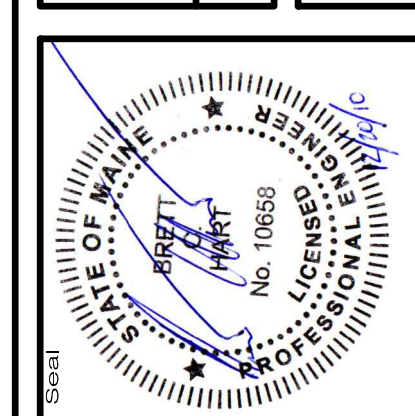

60606E

SEWALL
 JAMES W. SEWALL COMPANY / Since 1887
 800.646.4262

an integrated team of
 geospatial, engineering,
 planning and natural
 resource consultants

NOT FOR CONSTRUCTION